


9/1/2010 1:19:37 PM, 1:1

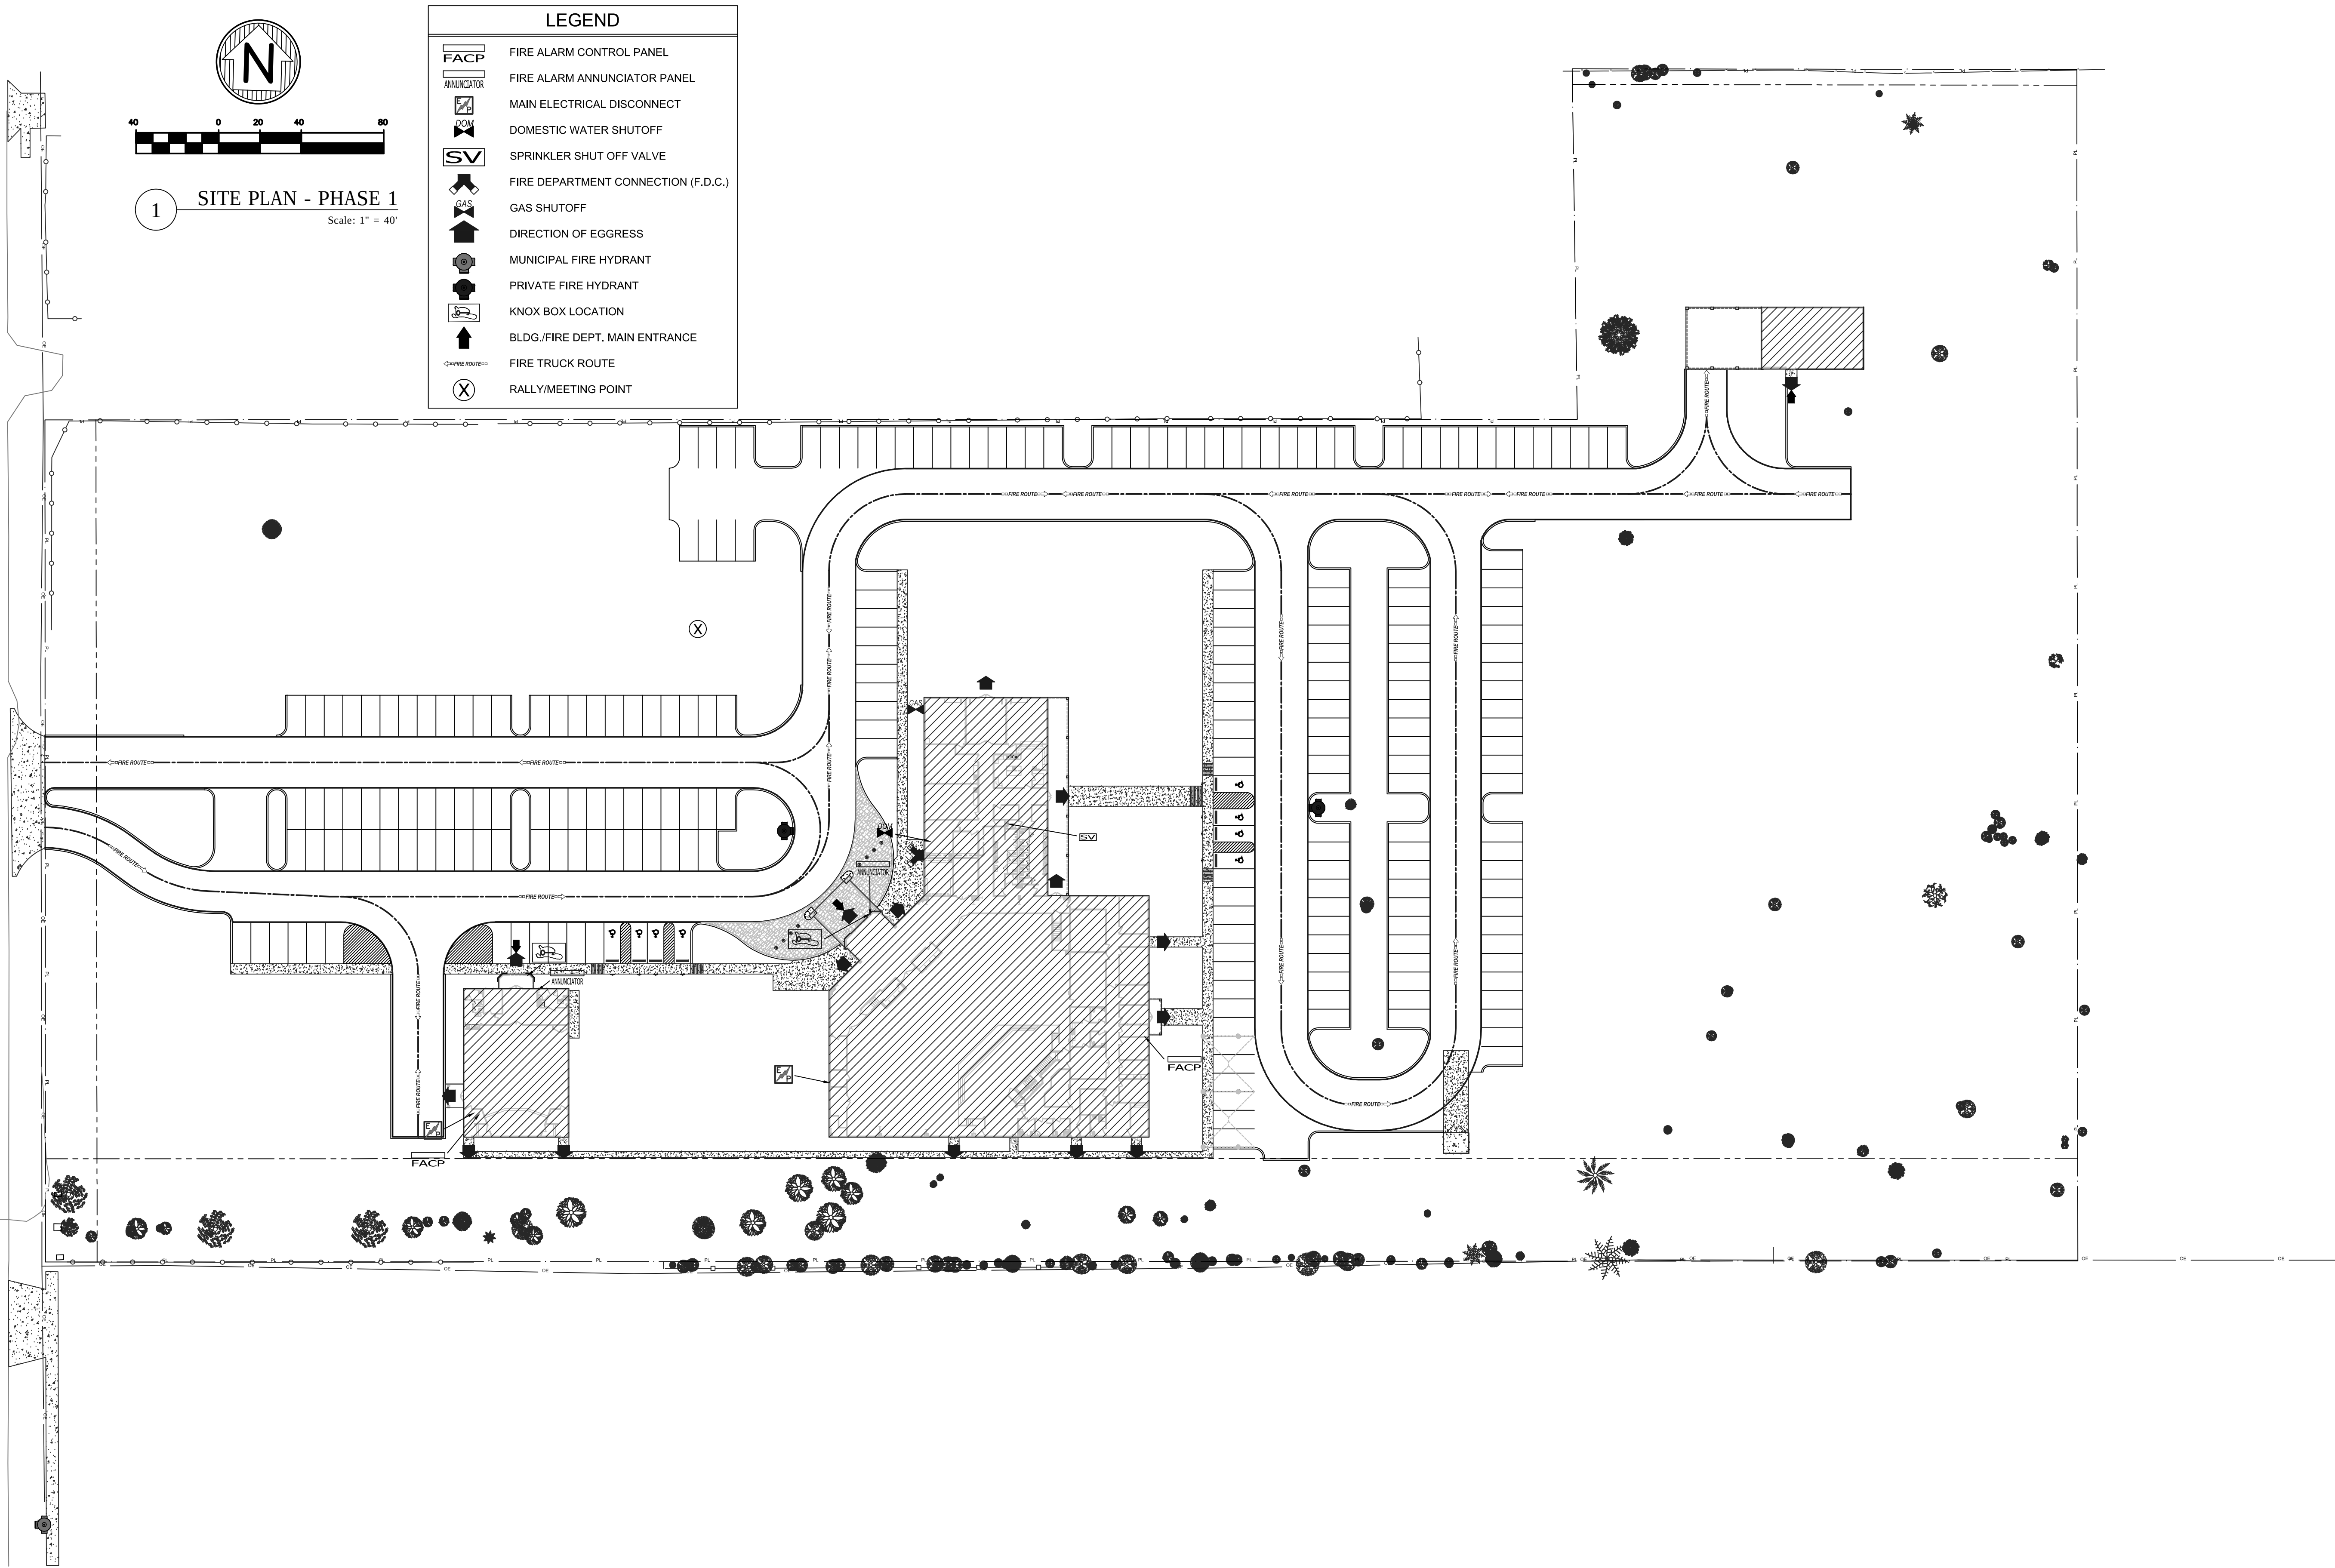



TIMBERCON CONSTRUCTION, INC.
1241 UNIVERSAL CITY BLVD.
UNIVERSAL CITY, TX 78148
(210) 590-2544
(210) 590-2352 FAX
www.timbercon.net

TRUE VISION CHURCH
2803 CECILIA ROAD
KIRBY, TX 75753
(210) 590-4460
(210) 590-2540 FAX
www.truevisionchurch.org

REVISIONS:	
DATE	BY

These drawings and accompanying specifications are the sole property of Timbercon Construction, Inc. and may not be used for any other project or by any other person or general contractor without prior written permission from Timbercon Construction, Inc.


SHEET NUMBER

F1.0

JULY 28, 2010

FIRE PROTECTION SITE PLAN - PHASE 1

9/1/2010 1:19:55 PM, 1:1

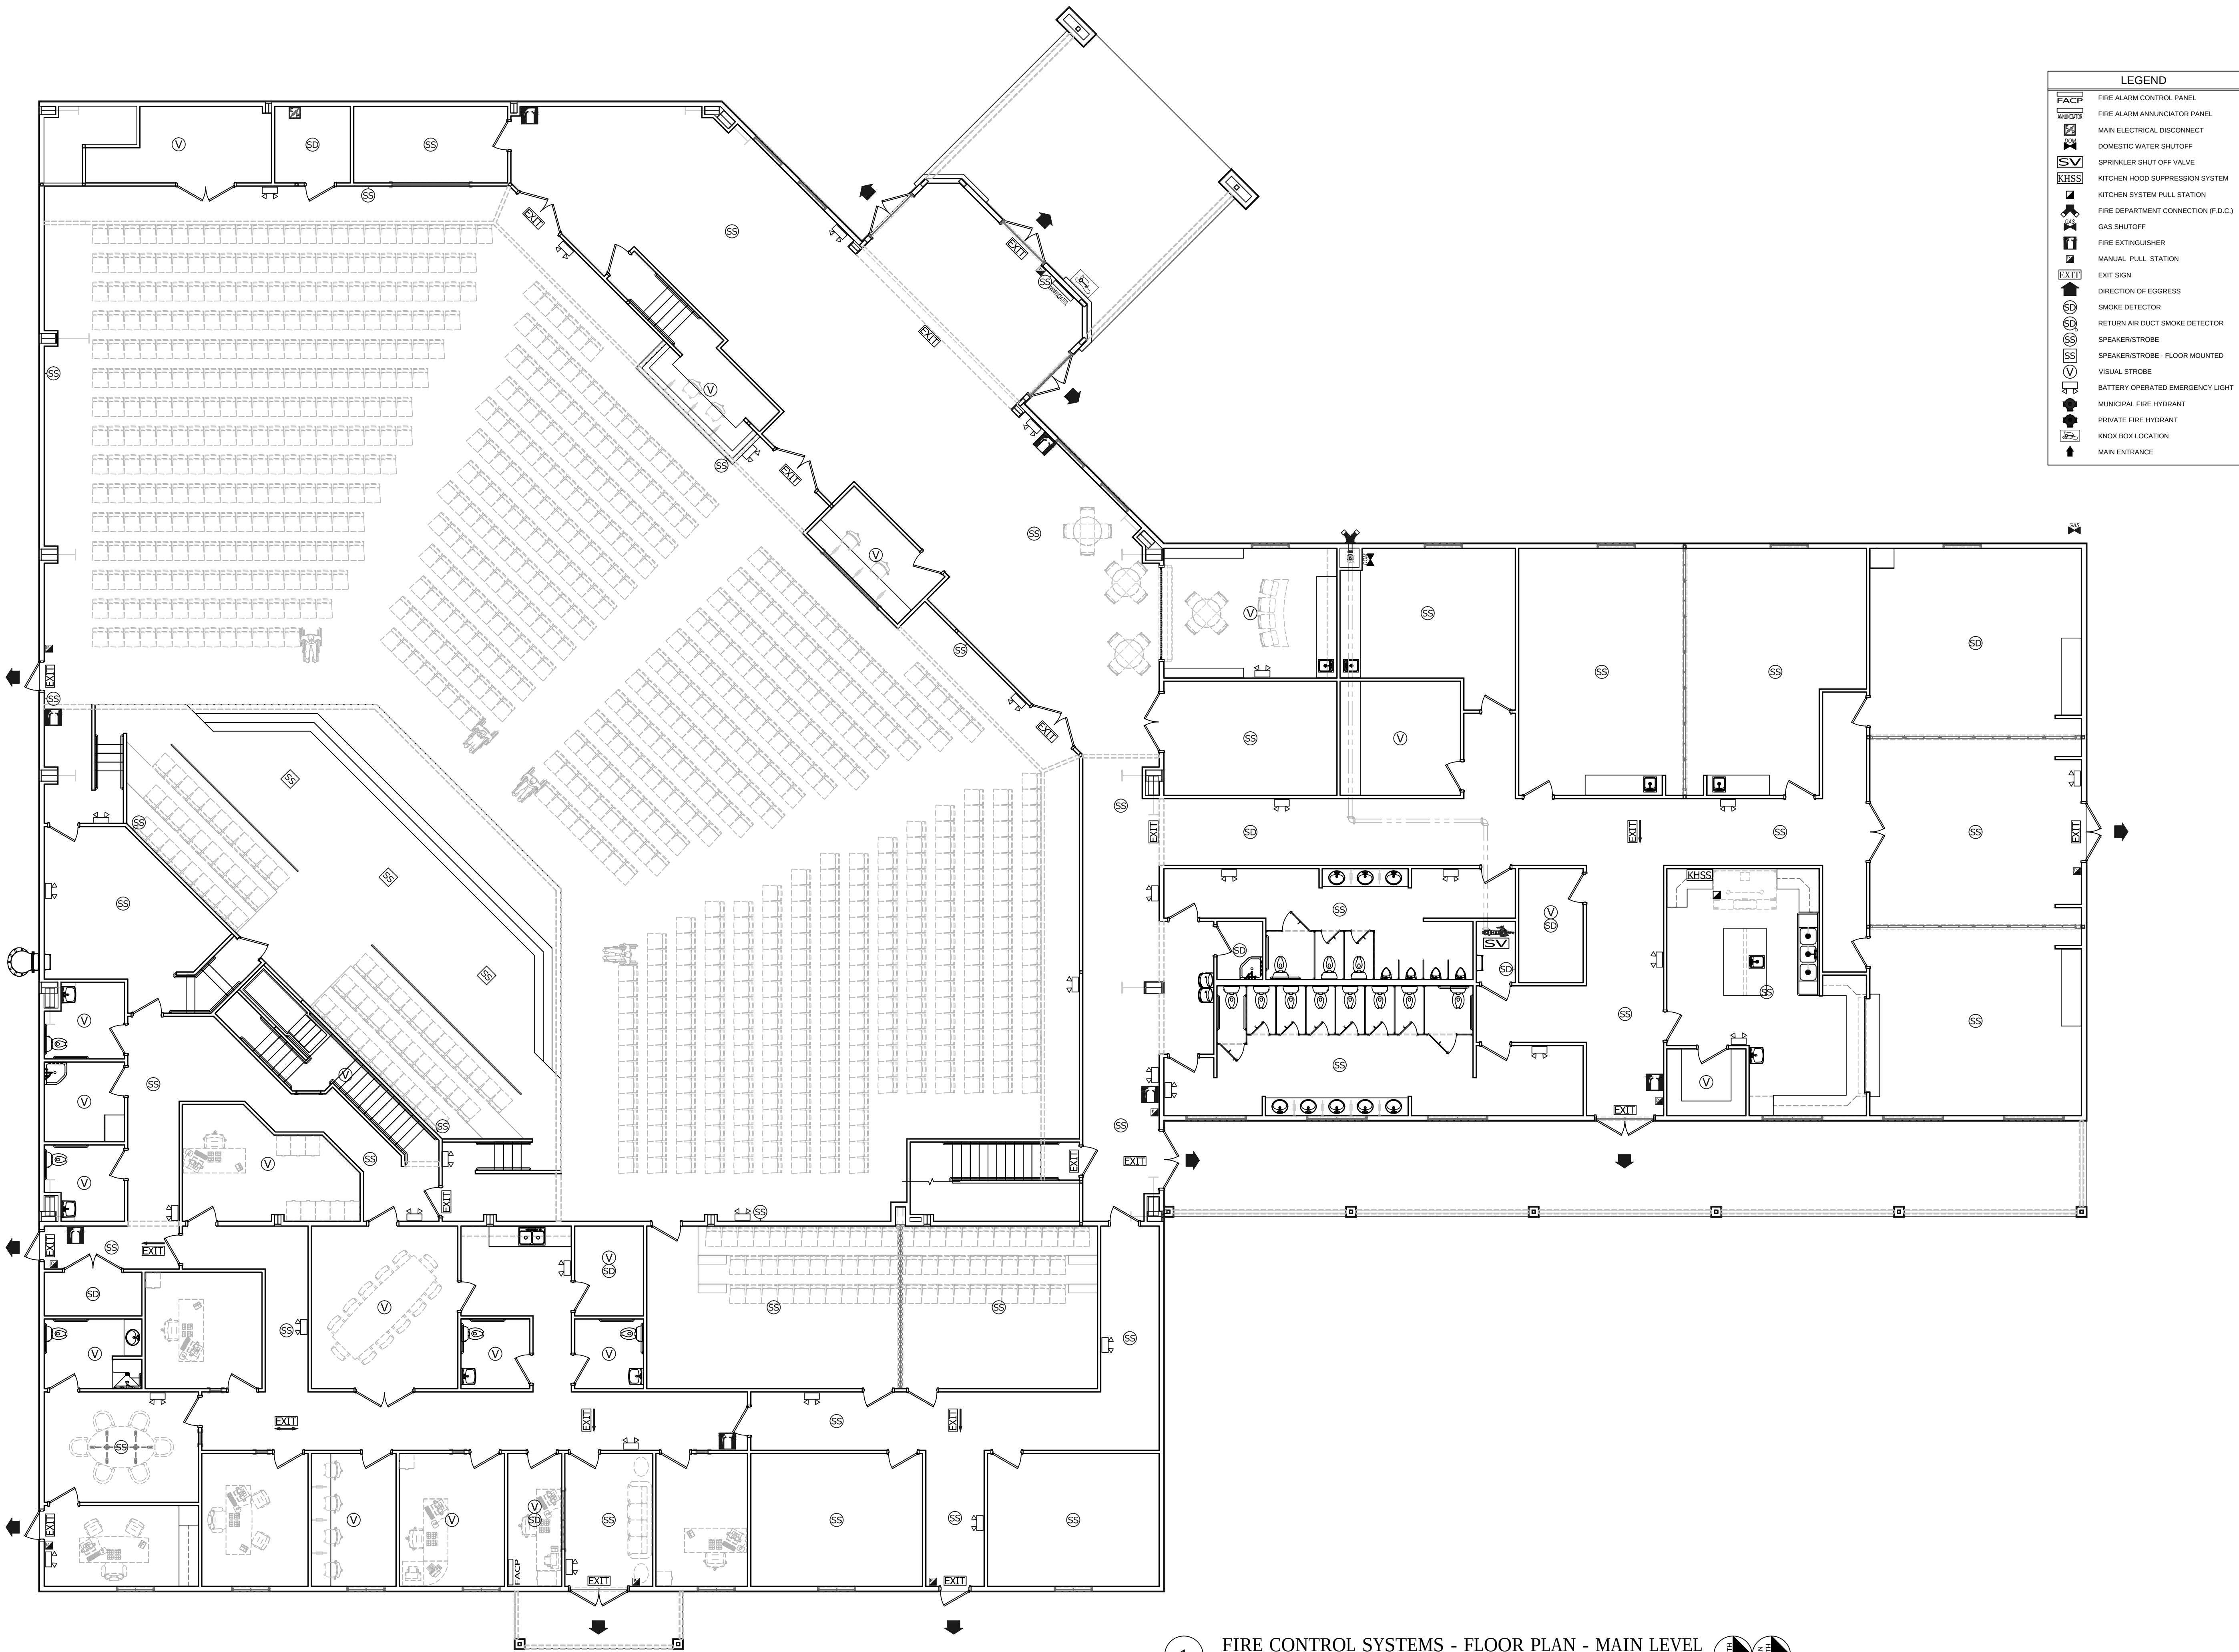

1 FIRE CONTROL SYSTEMS - FLOOR PLAN - MAIN LEVEL
Scale: 1/8" = 1'

REVISIONS:	
DATE	BY


These drawings and accompanying specifications are the sole property of Timbercon Construction, Inc. and may not be used for any other project or by any other person or general contractor without prior written permission from Timbercon Construction, Inc.

TRUE VISION CHURCH
2835 CRAWFORD ROAD
KIRBY, TX 75753
(210) 590-4460
(210) 590-2540 FAX
www.truevisionchurch.org


TIMBERCON CONSTRUCTION, INC.
1241 UNIVERSAL CITY BLVD.
UNIT 100
UNIVERSAL CITY, TX 78148
(210) 590-2544
(210) 590-2352 FAX
www.timbercon.net

SHEET NUMBER
F2.1
JULY 28, 2010

9/1/2010 1:20:07 PM, 1:1

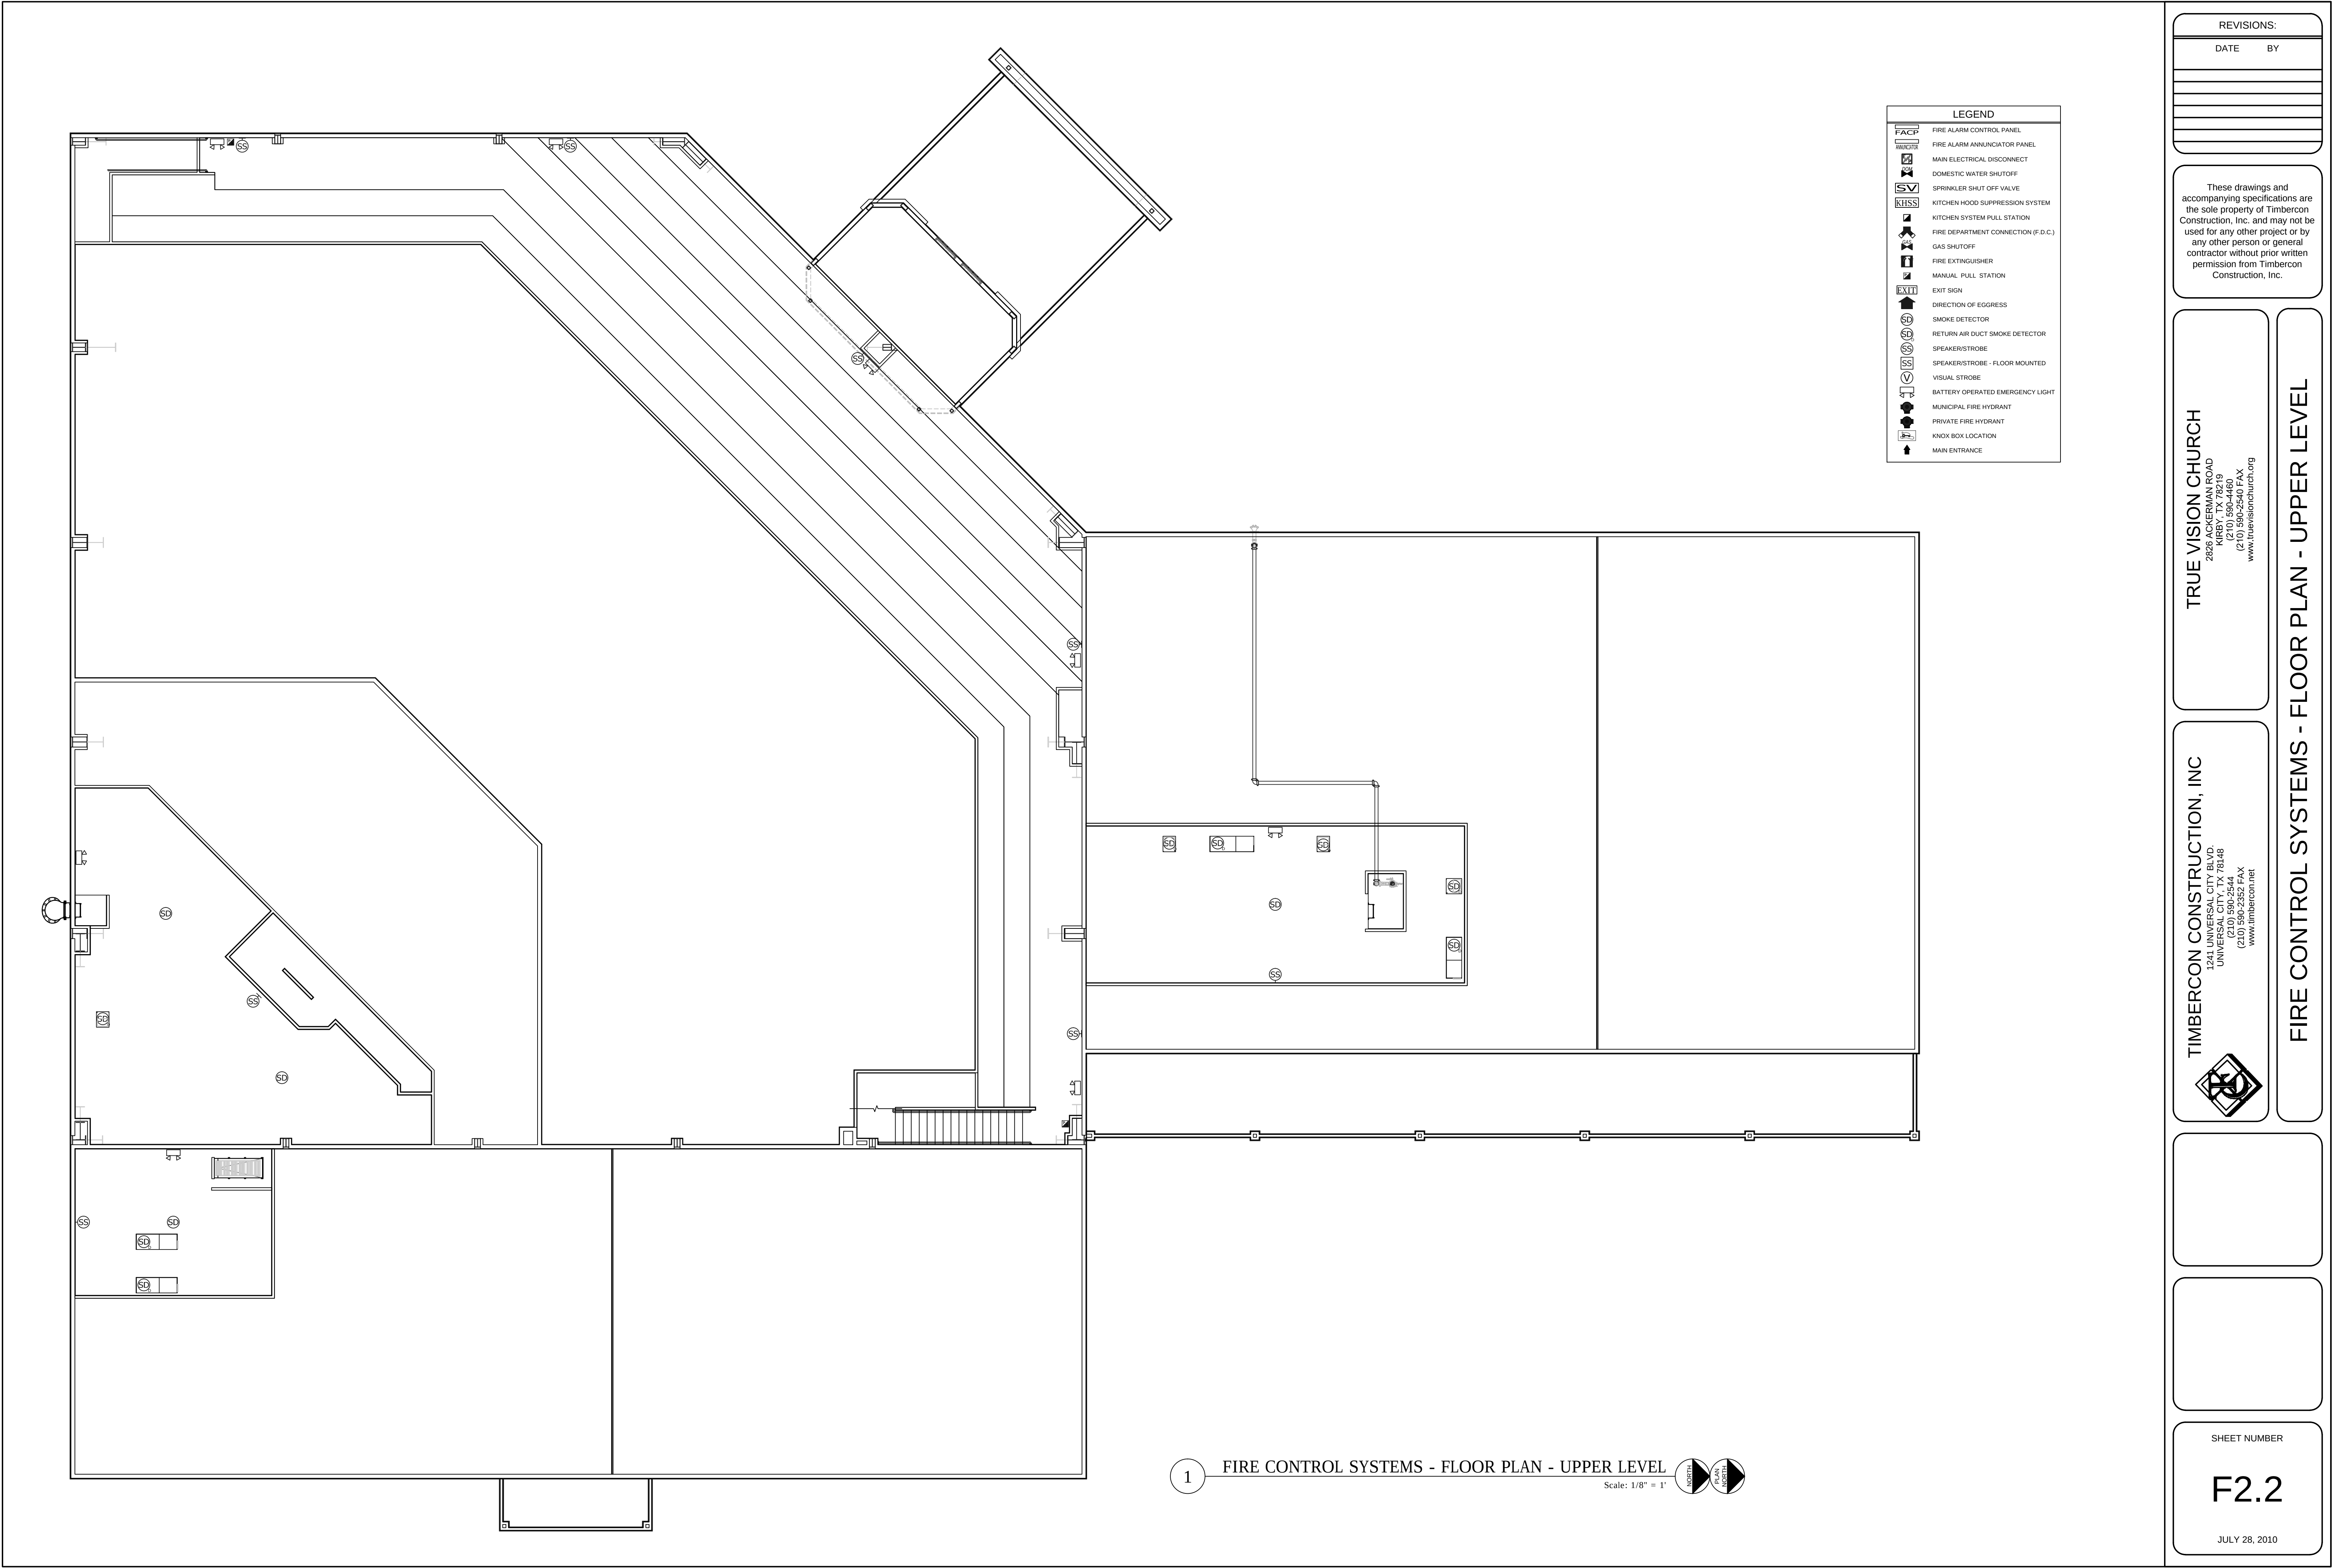

9/1/2010 1:20:16 PM, 1:1

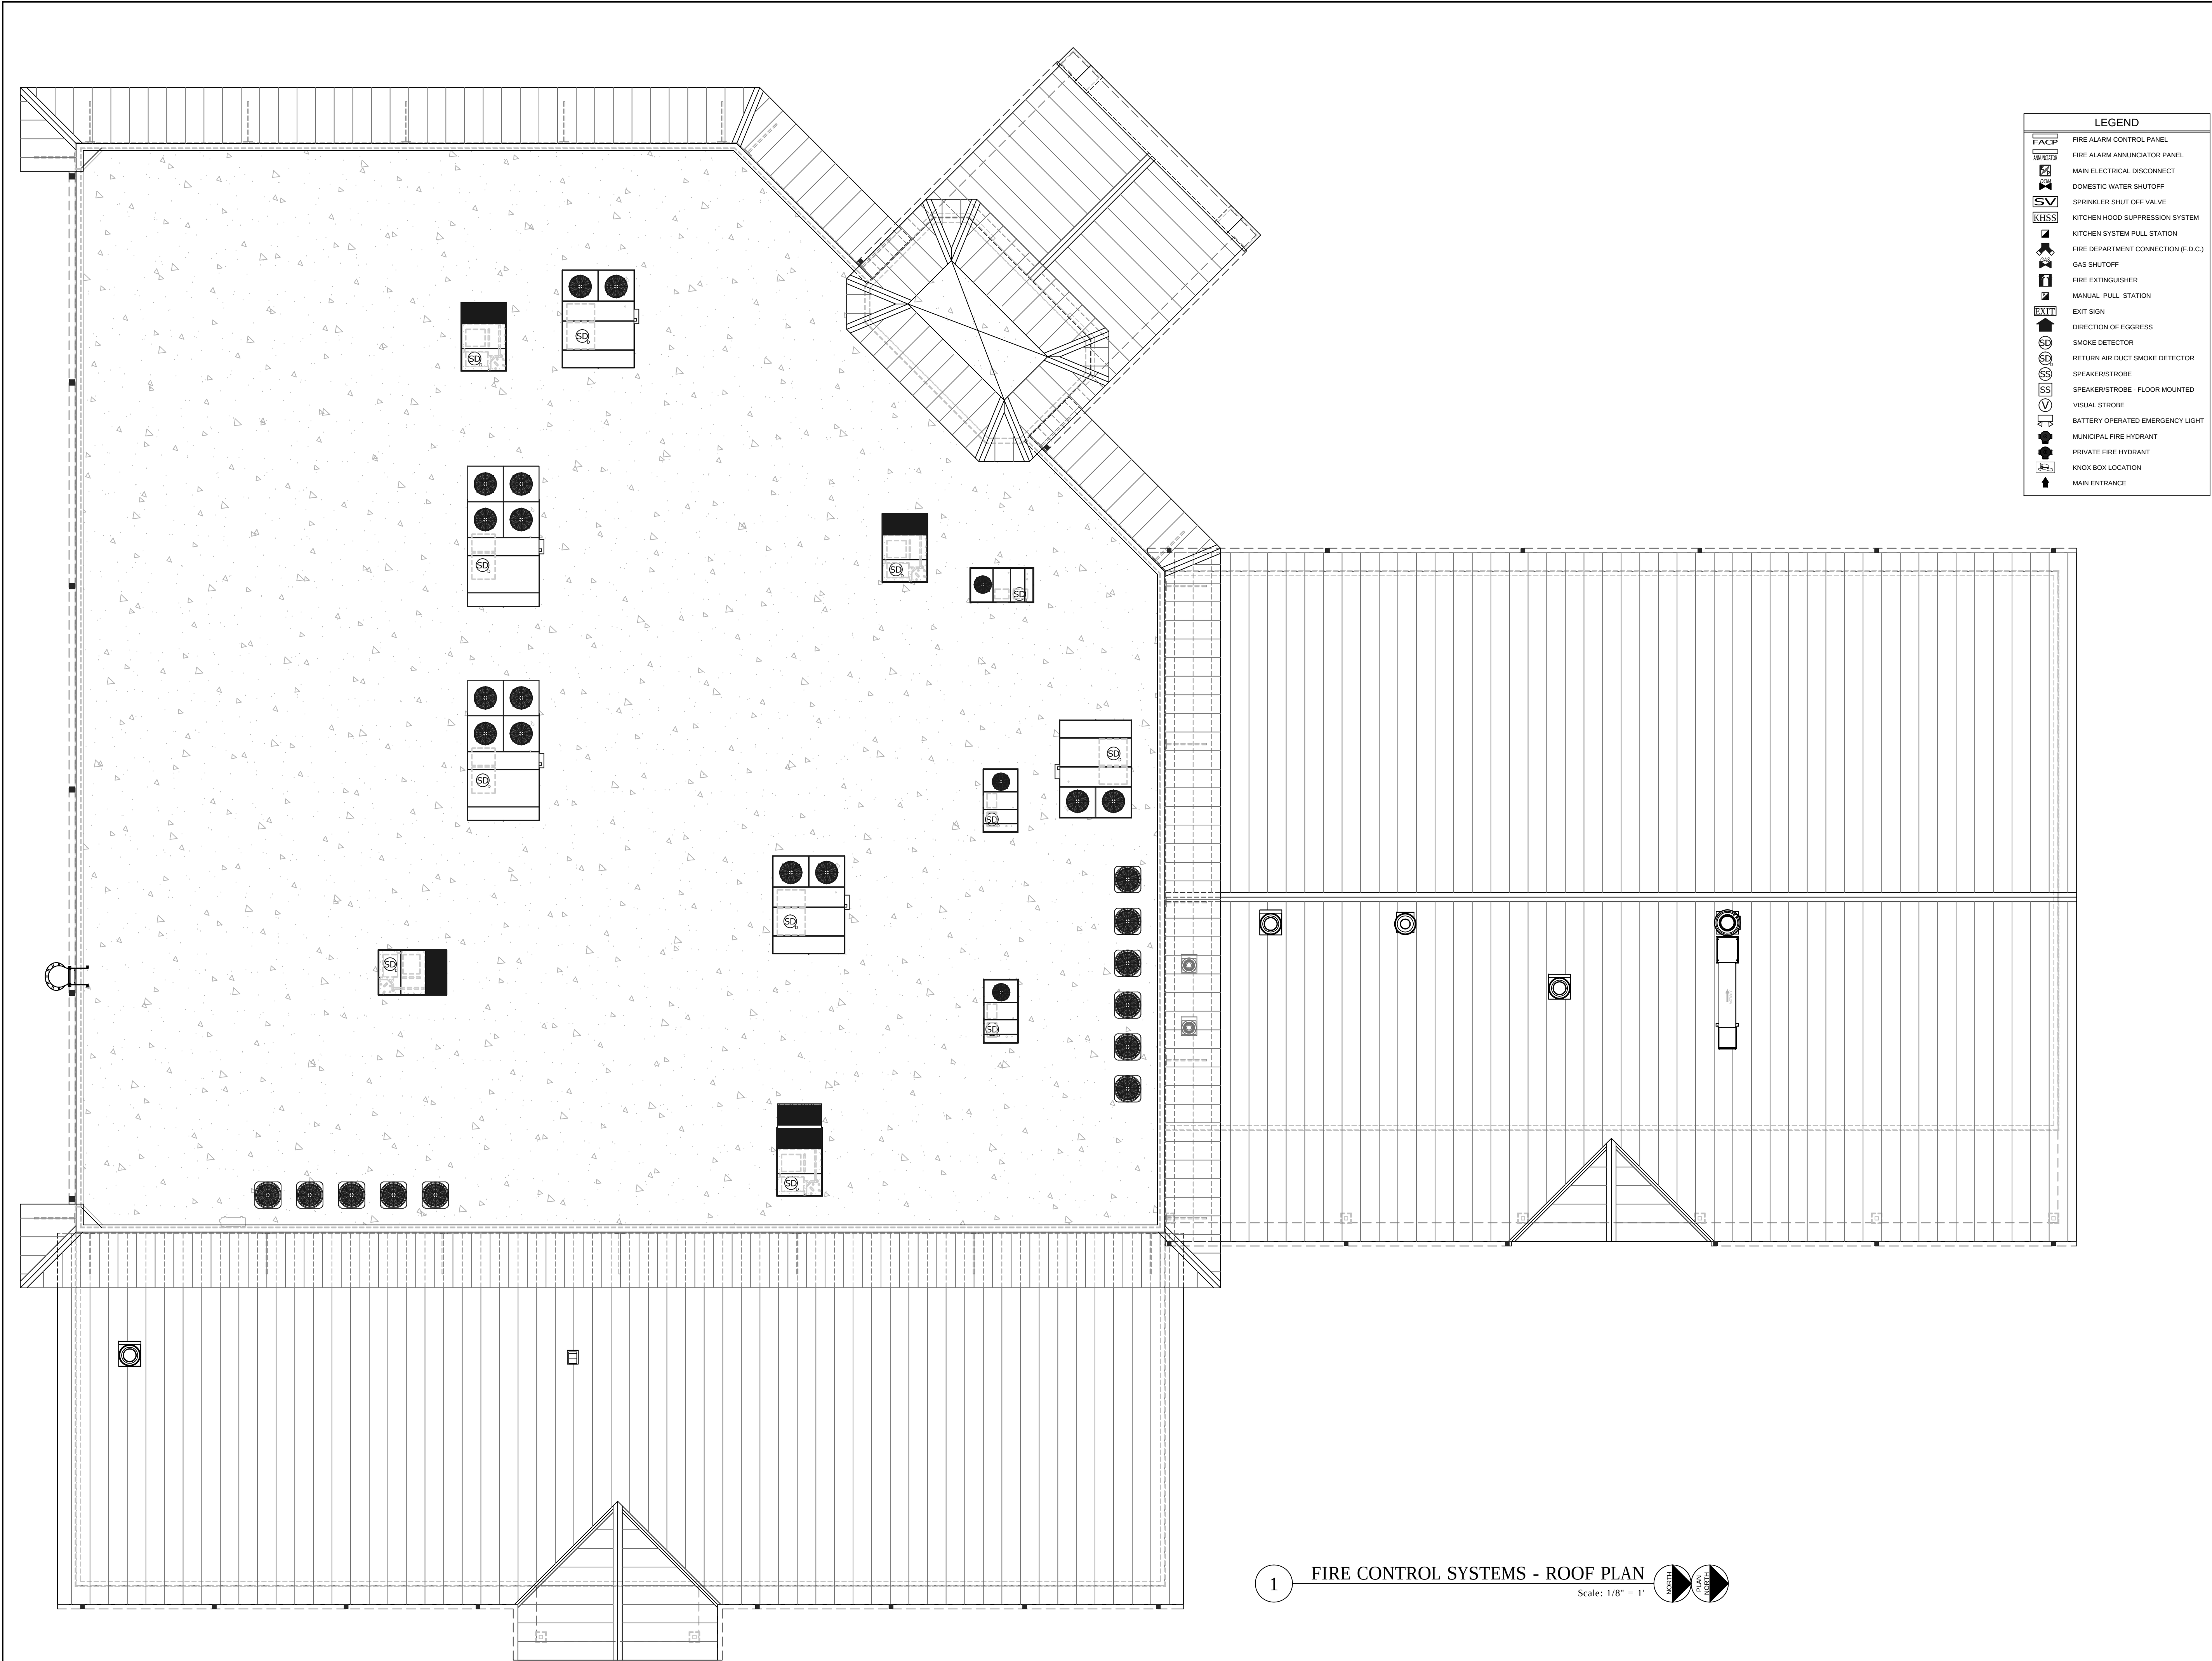

REVISIONS:	
DATE	BY

These drawings and accompanying specifications are the sole property of Timbercon Construction, Inc. and may not be used for any other project or by any other person or general contractor without prior written permission from Timbercon Construction, Inc.

TRUE VISION CHURCH
2835 LINDEN ROAD
KIRBY, TX 75753
(210) 590-4460
(210) 590-2540 FAX
www.truevisionchurch.org


TIMBERCON CONSTRUCTION, INC.
1241 UNIVERSAL CITY BLVD.
UNIVERSAL CITY, TX 78148
(210) 590-2544
(210) 590-2352 FAX
www.timbercon.net



FIRE CONTROL SYSTEMS - ROOF PLAN

SHEET NUMBER
F2.3
JULY 28, 2010

9/1/2010 1:20:22 PM, 1:1

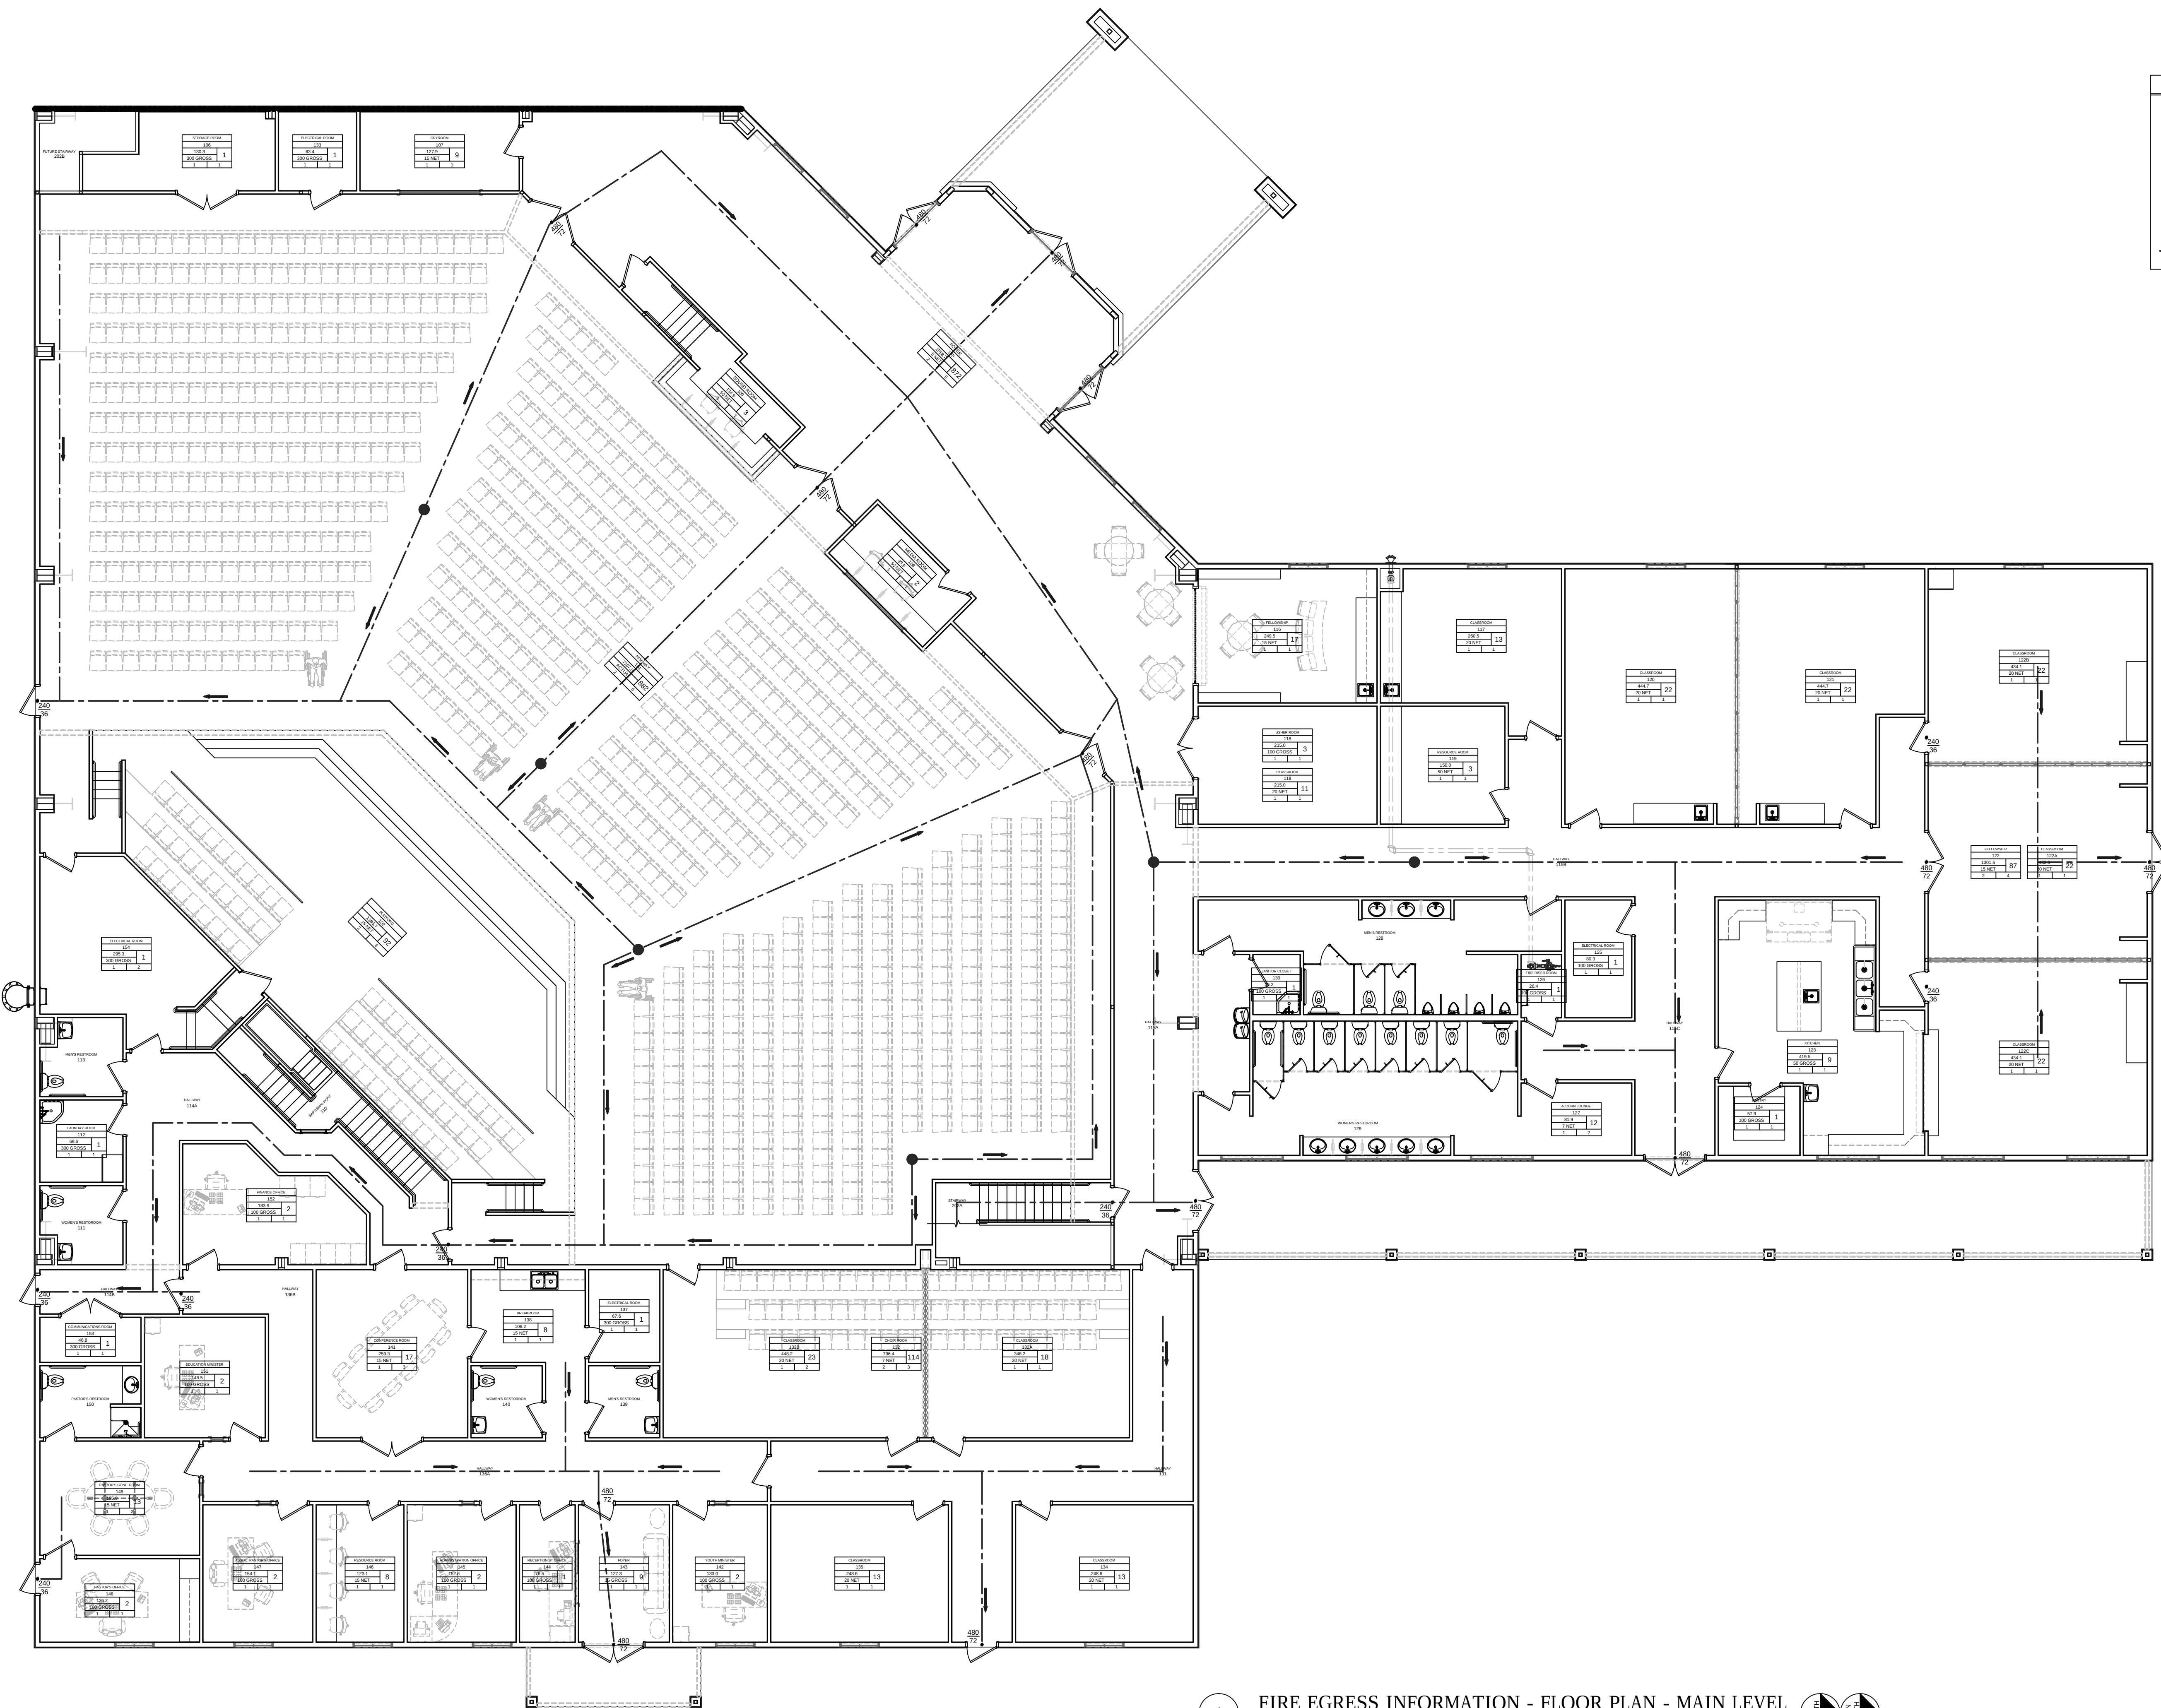

1 FIRE EGRESS INFORMATION - FLOOR PLAN - MAIN LEVEL
Scale: 1/8" = 1'

REVISIONS:	
DATE	BY


These drawings and accompanying specifications are the sole property of Timbercon Construction, Inc. and may not be used for any other project or by any other person or general contractor without prior written permission from Timbercon Construction, Inc.

TRUE VISION CHURCH
2828 CEMANA ROAD
KIRBY, TX 75743
(210) 590-4460
(210) 590-2540 FAX
www.truevisionchurch.org


TIMBERCON CONSTRUCTION, INC.
1241 UNIVERSAL CITY BLVD.
UNIVERSAL CITY, TX 78746
(210) 590-2544
(210) 590-2352 FAX
www.timbercon.net

SHEET NUMBER
F3.1
JULY 28, 2010

FIRE EGRESS INFORMATION - FLOOR PLAN - MAIN LEVEL


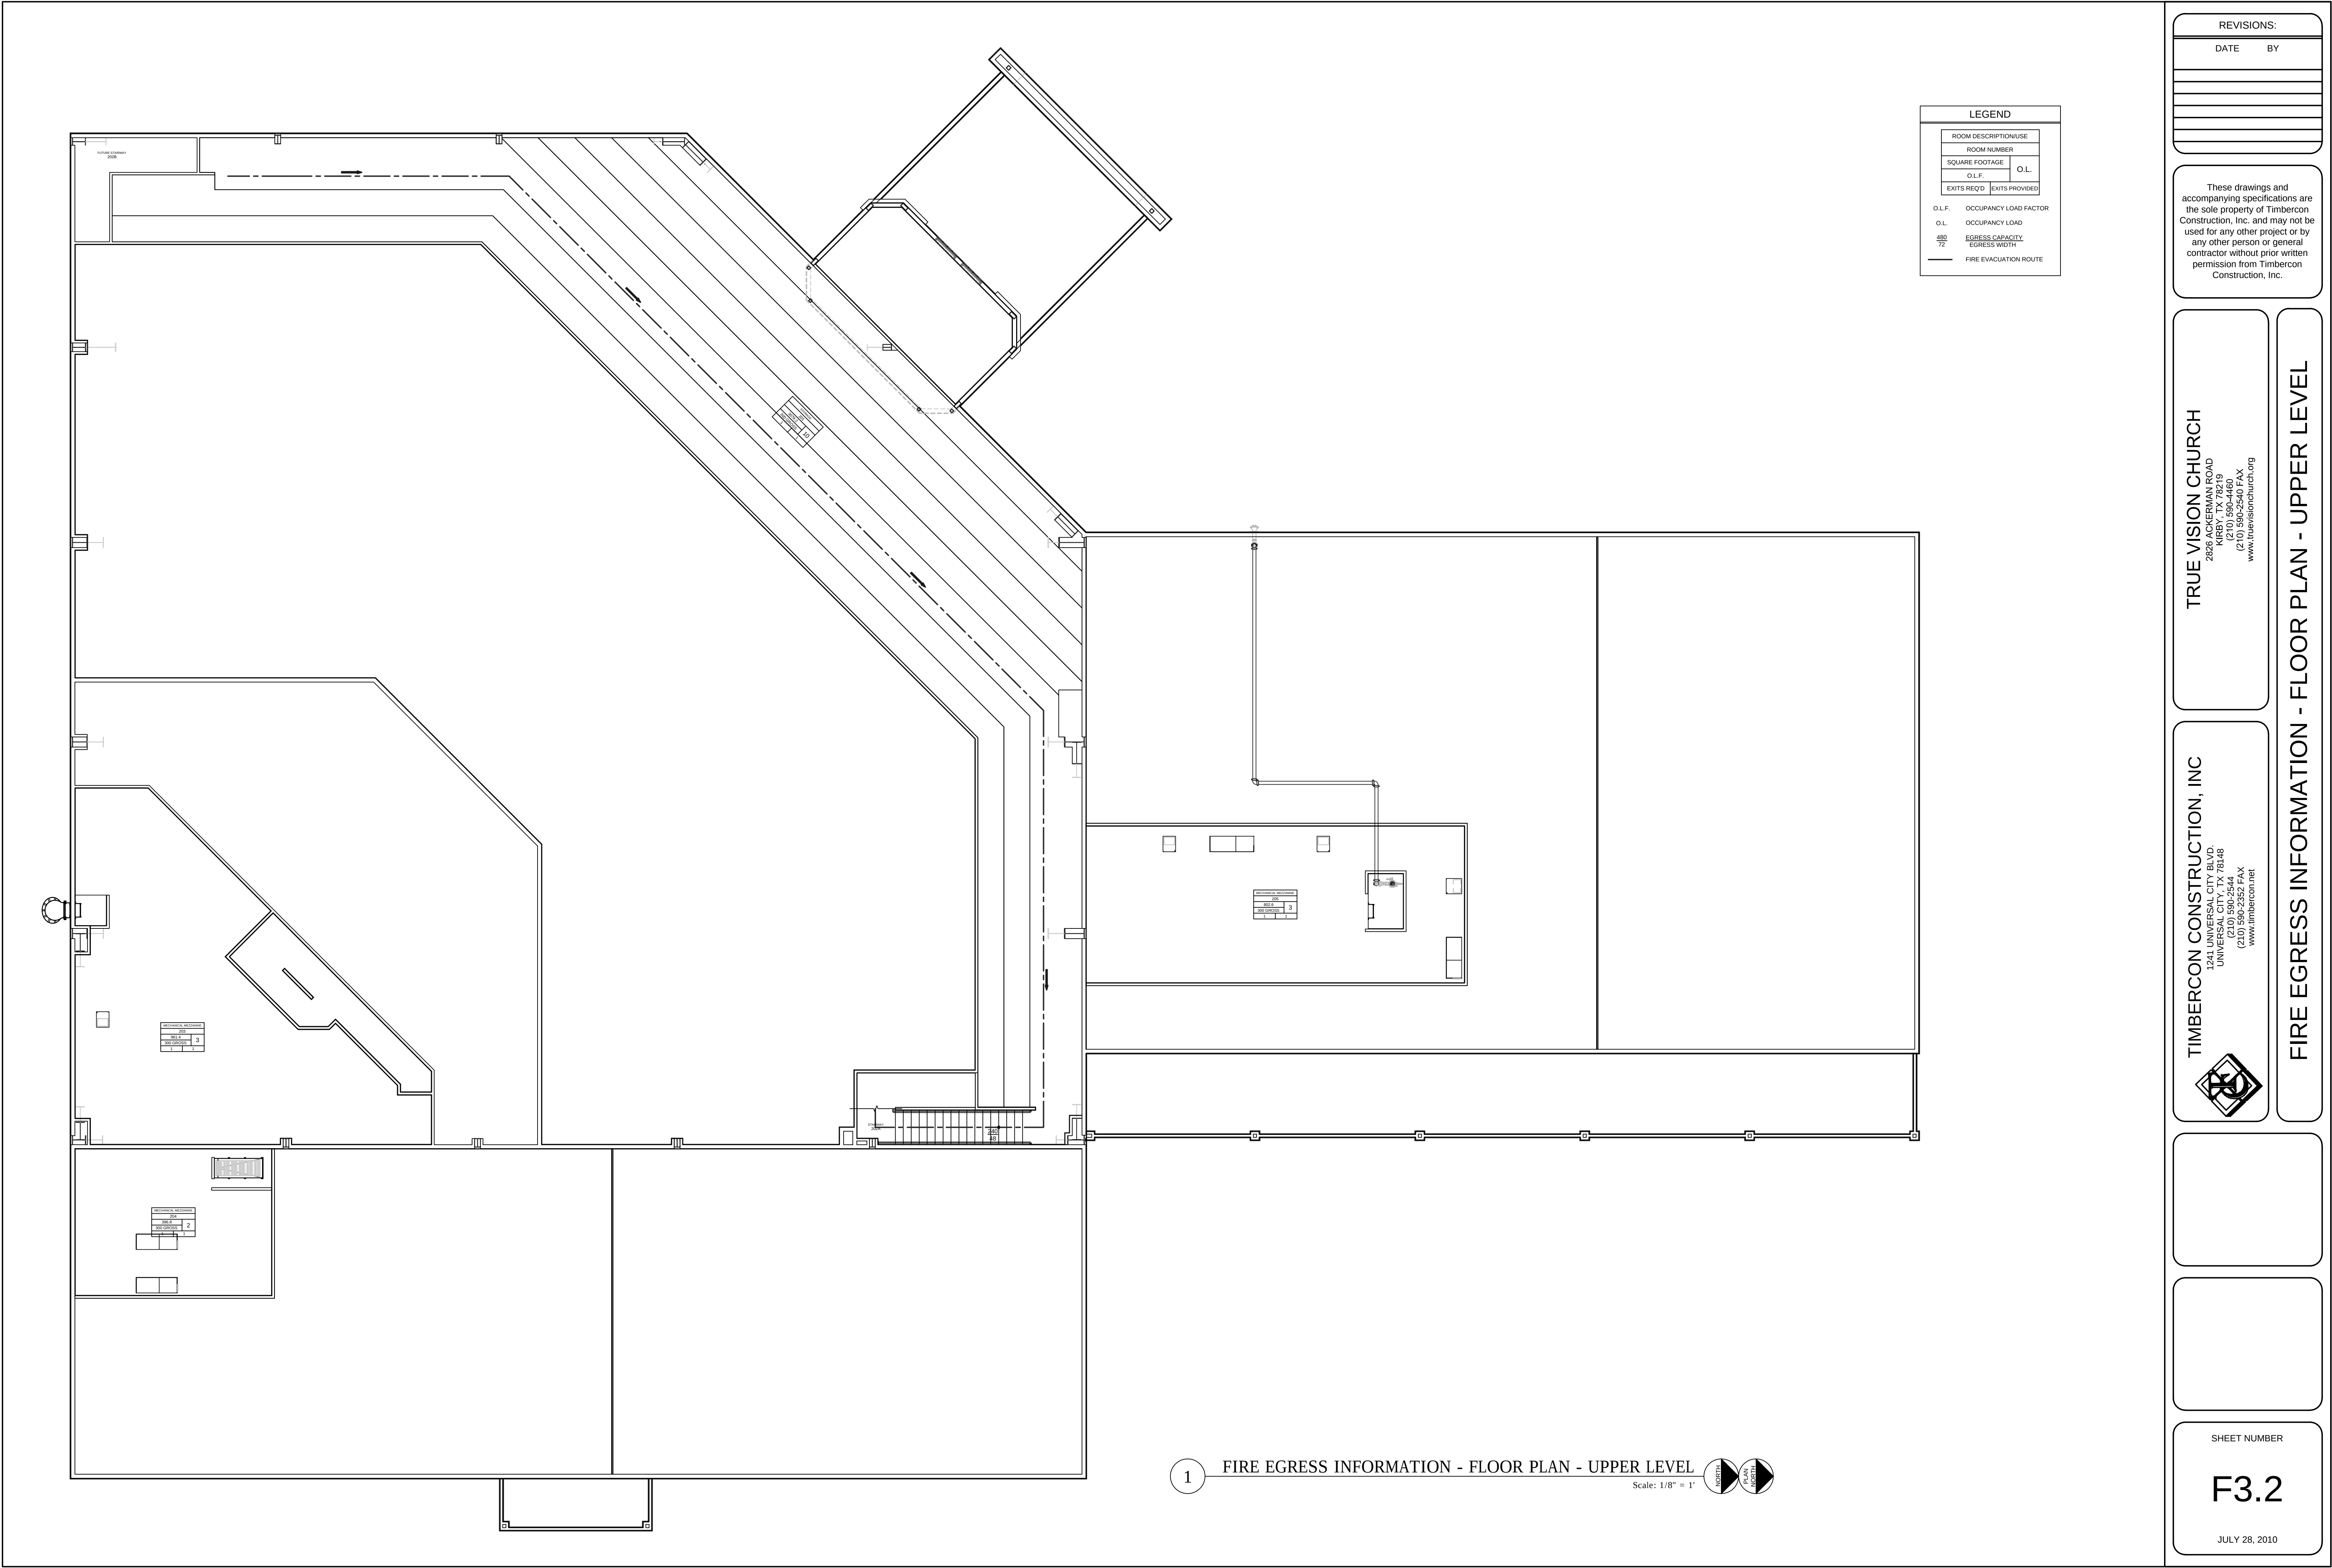


9/1/2010 1:20:49 PM, 1:1

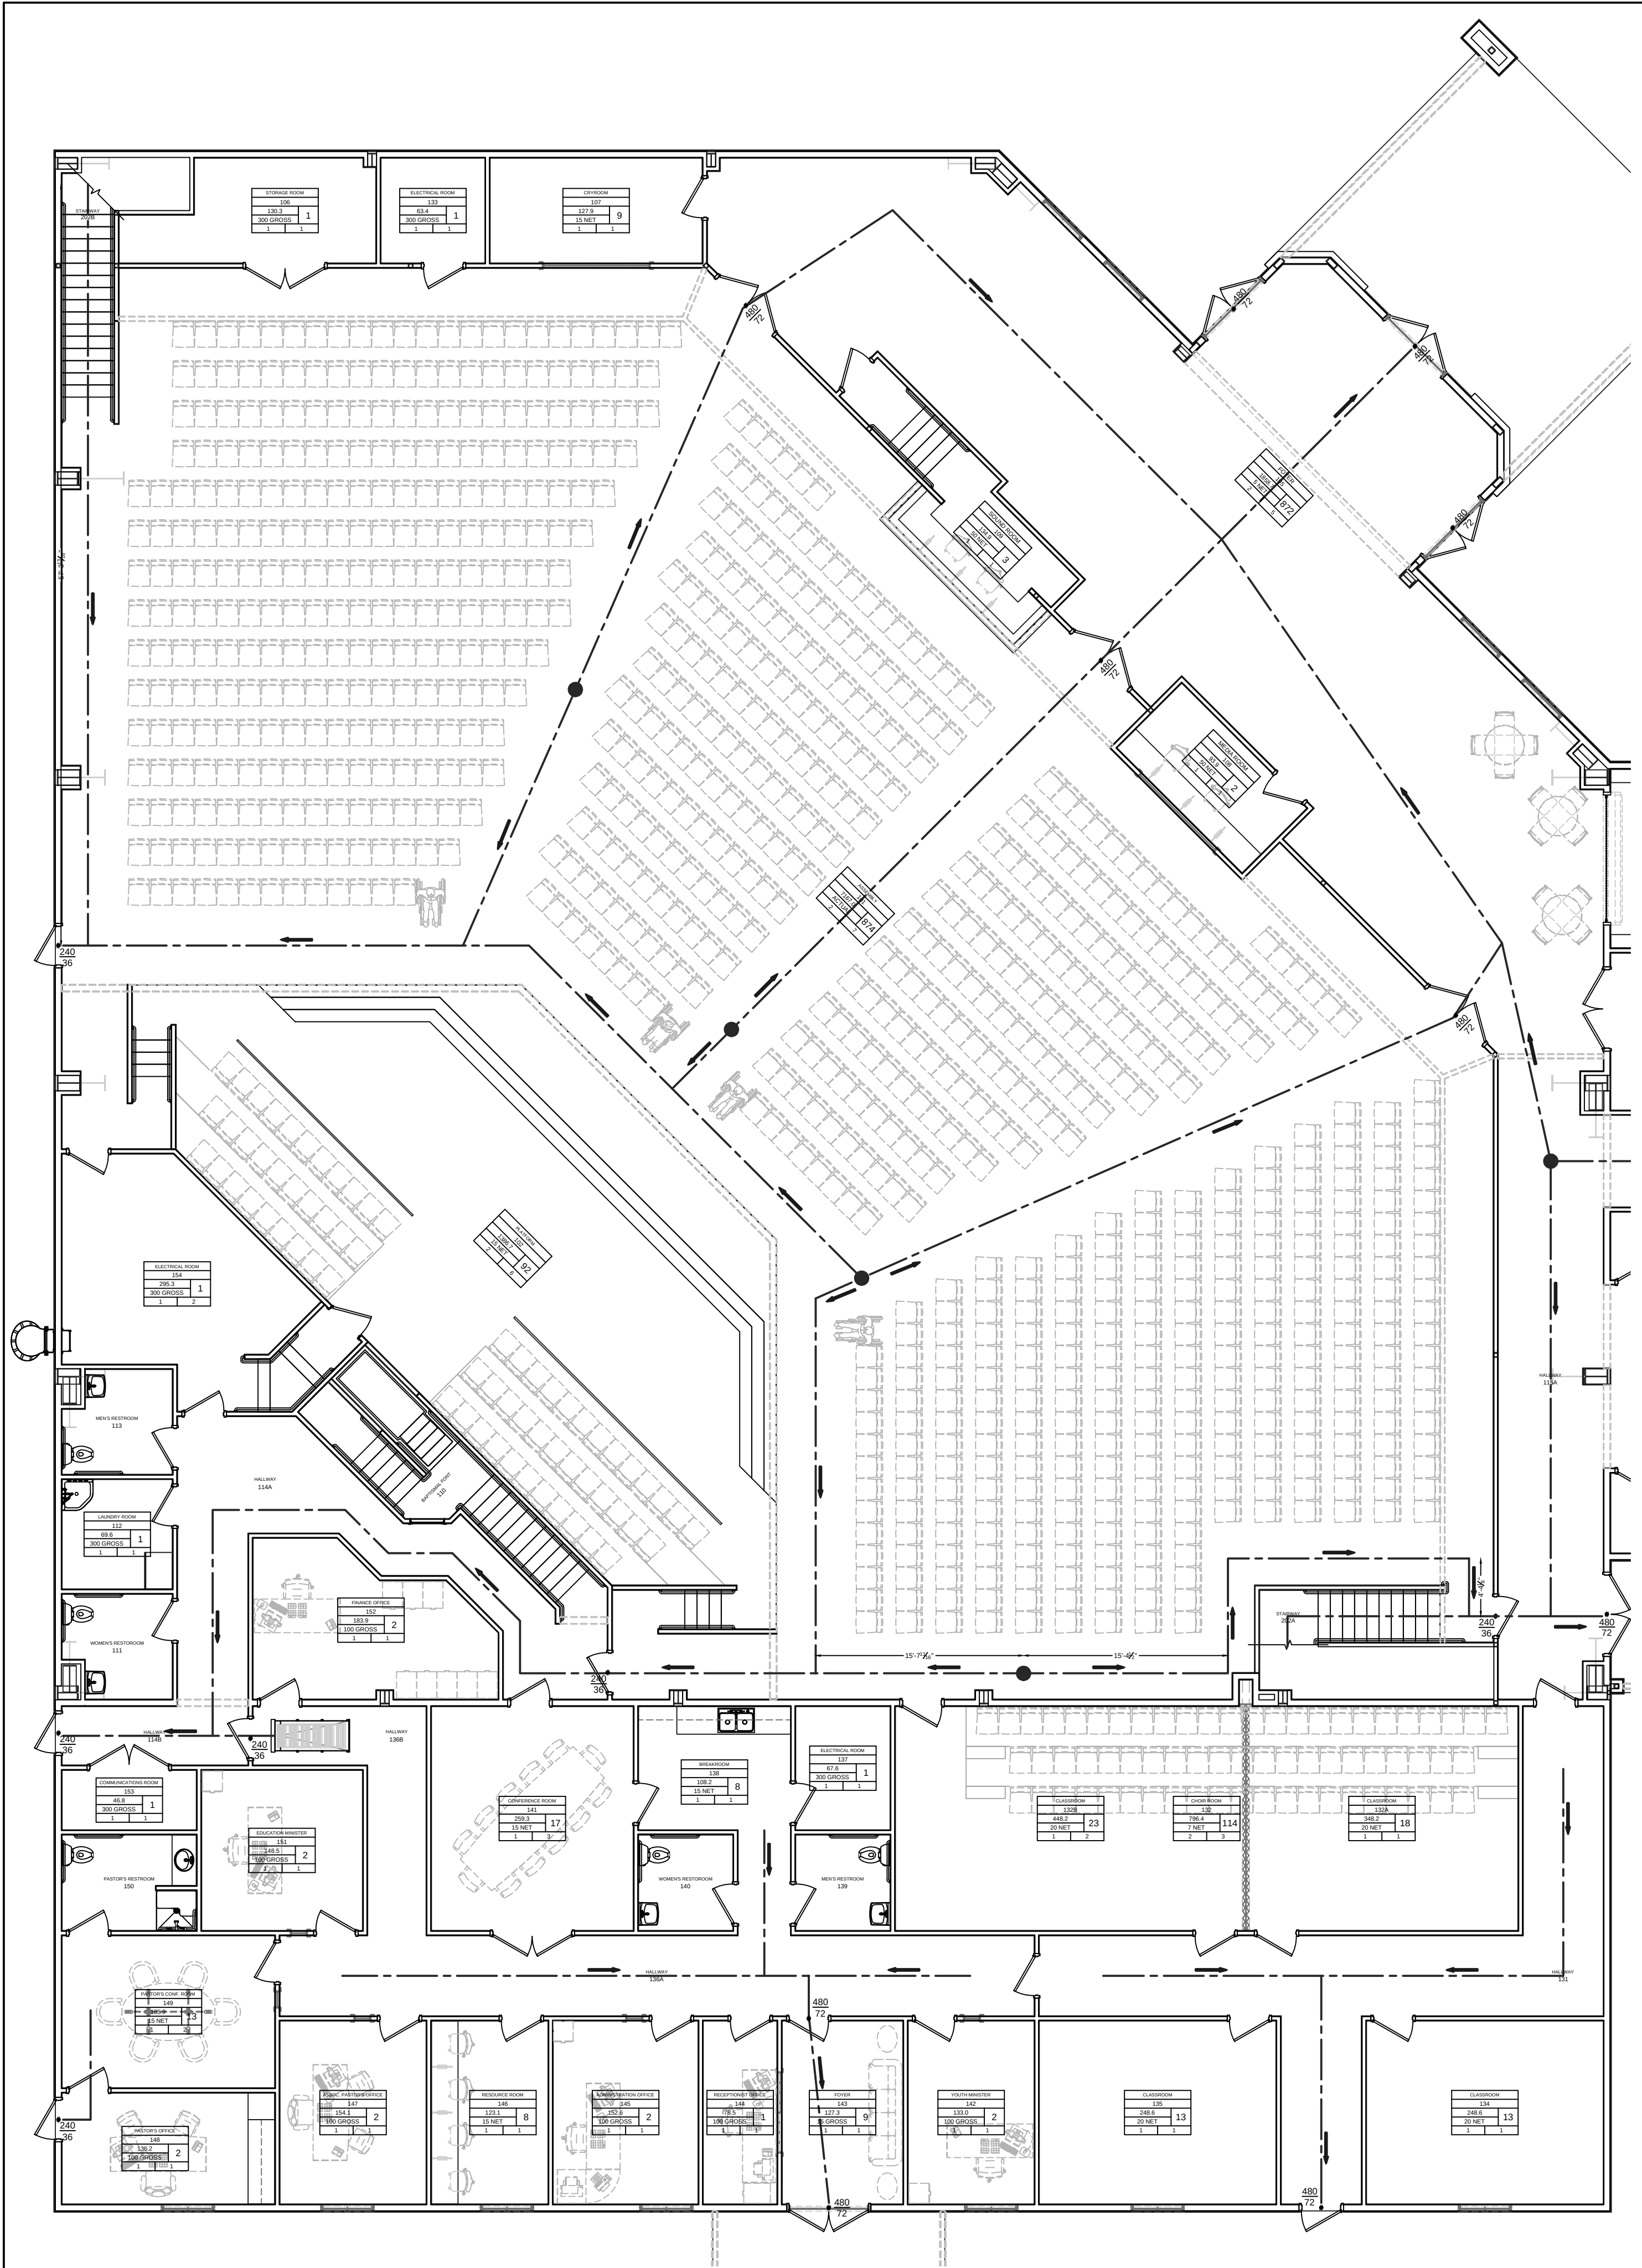


1 FIRE EGRESS INFORMATION - FLOOR PLAN - MAIN LEVEL (ALT. 1)

 Scale: 1/8" = 1"

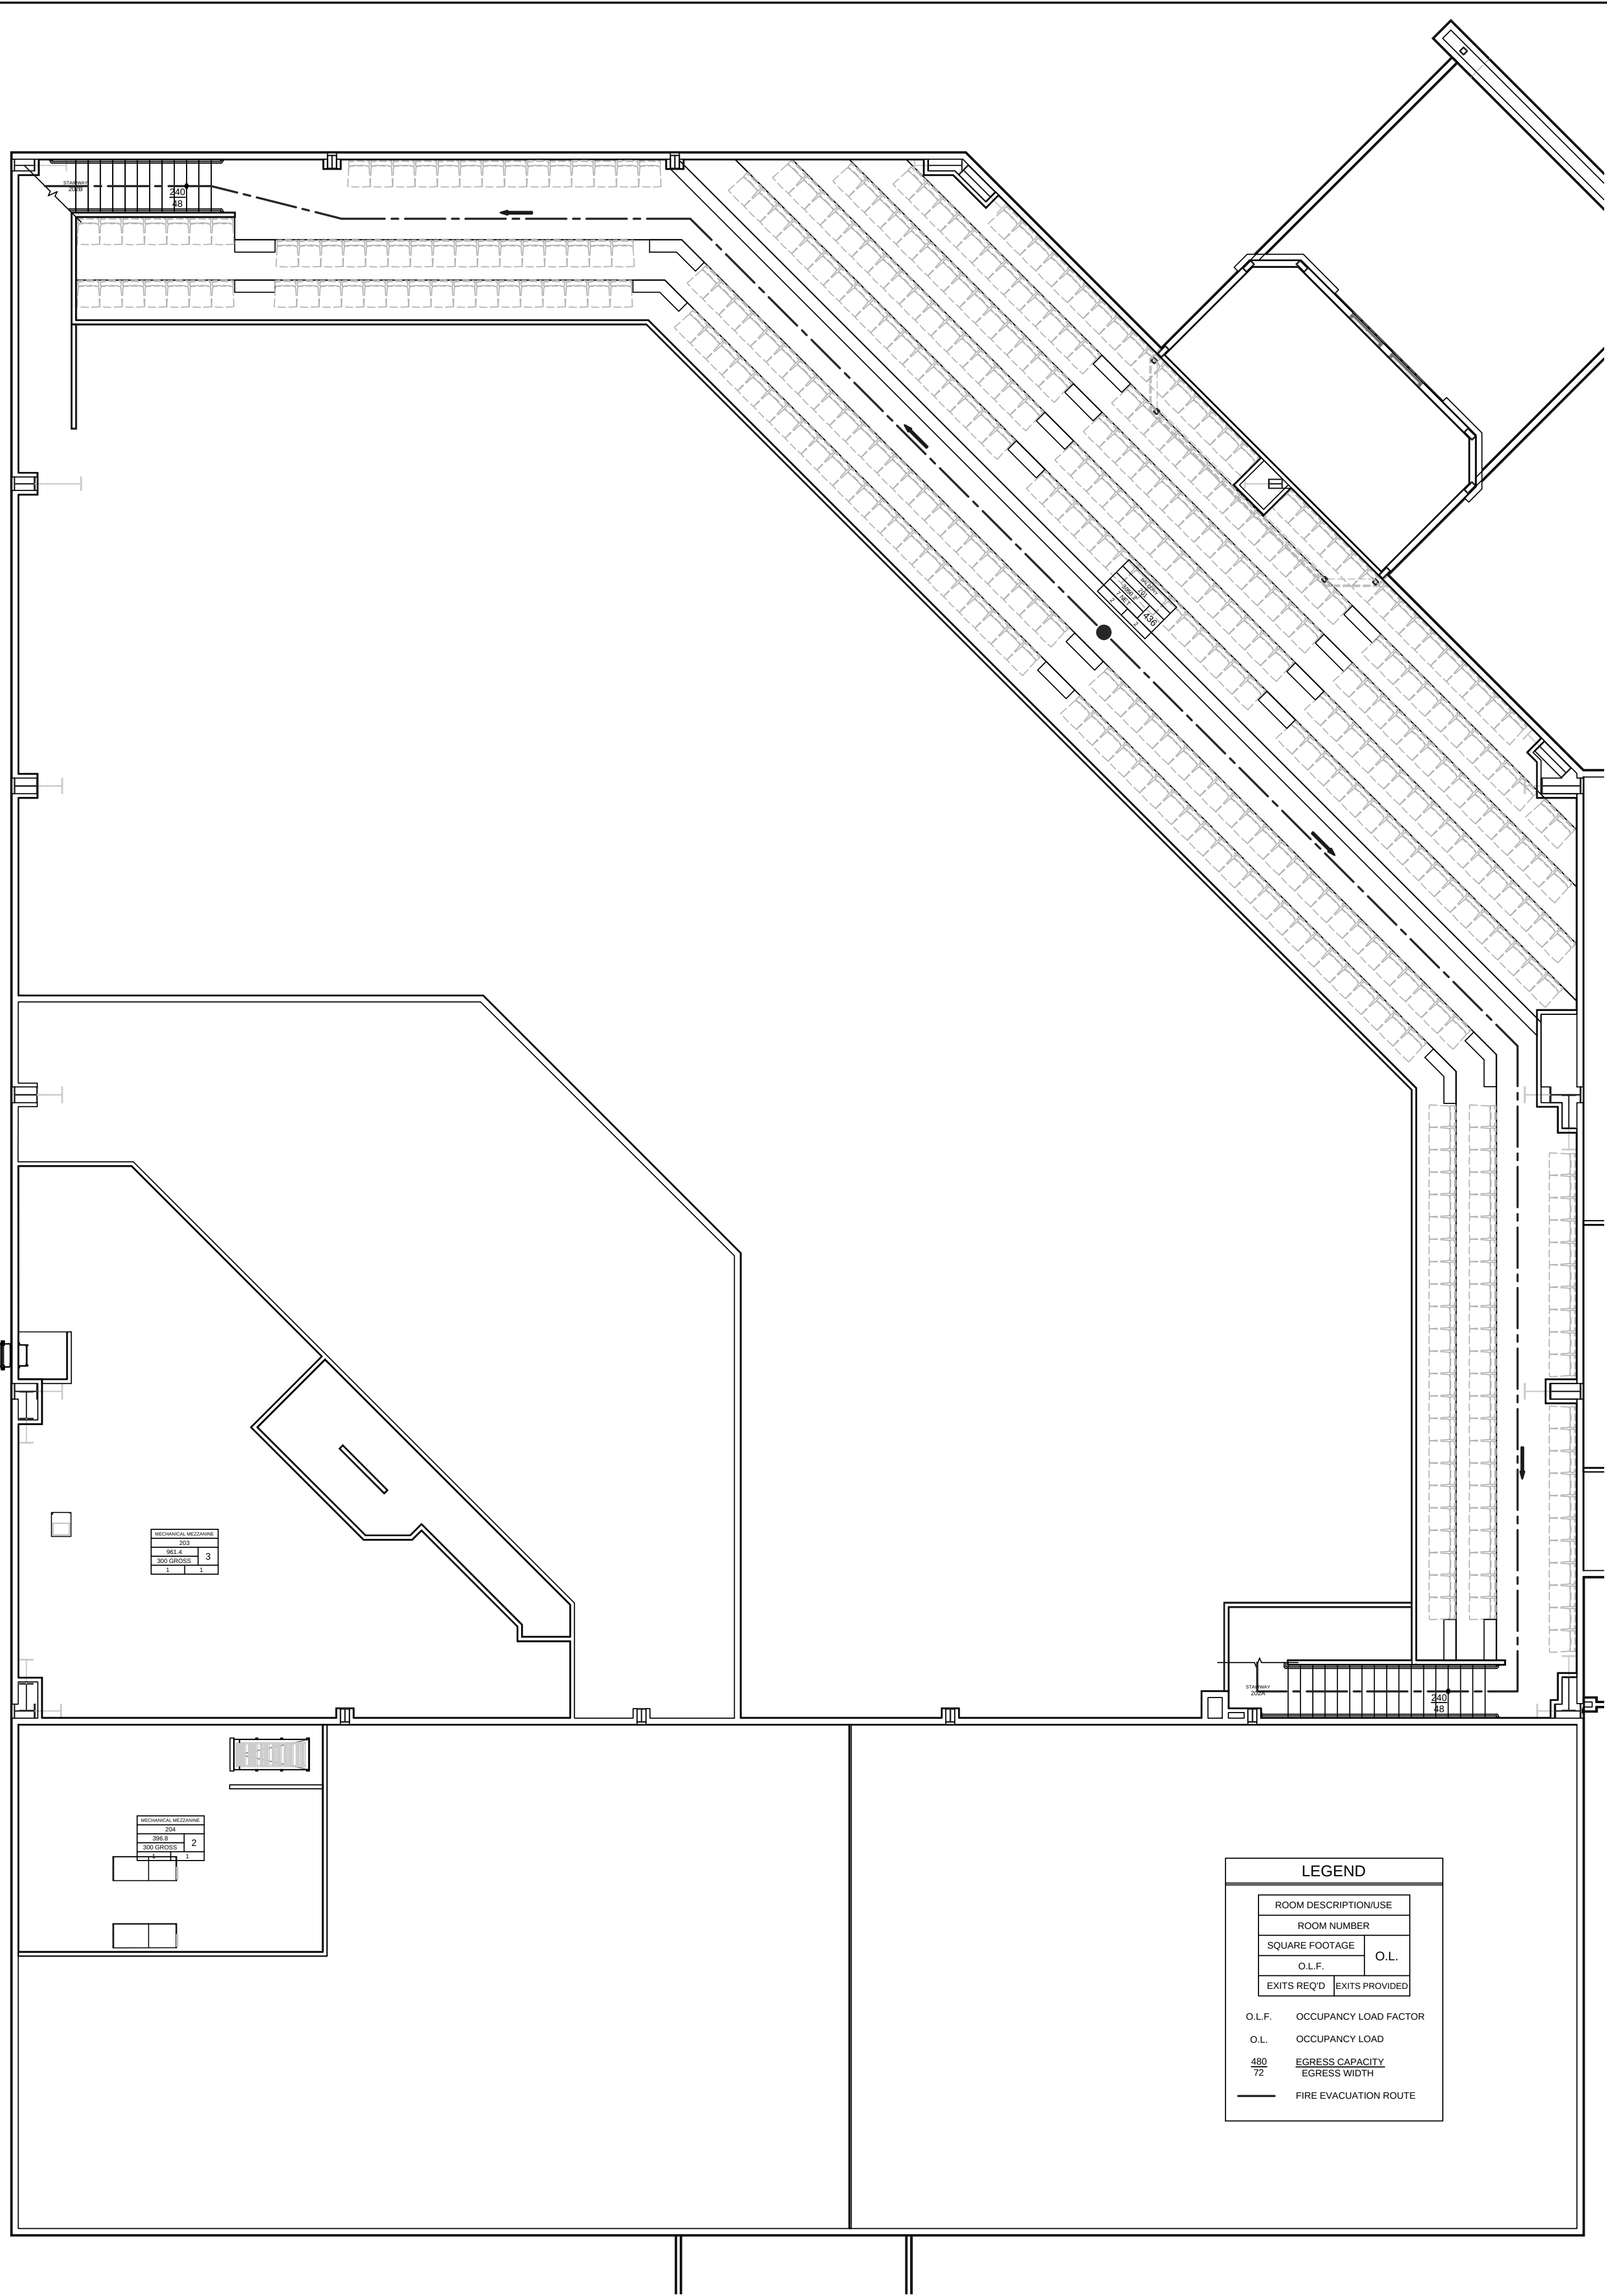

2 FIRE EGRESS INFORMATION - FLOOR PLAN - UPPER LEVEL (ALT. 1)

 Scale: 1/8" = 1"



REVISIONS:	
DATE	BY

These drawings and accompanying specifications are the sole property of Timbercon Construction, Inc. and may not be used for any other project or by any other person or general contractor without prior written permission from Timbercon Construction, Inc.

TRUE VISION CHURCH
2800 GARDEN ROAD
KIRBY, TX 75215
(210) 590-4460
(210) 590-2540 FAX
www.truevisionchurch.org

TIMBERCON CONSTRUCTION, INC.
1241 UNIVERSAL CITY BLVD.
UNIVERSAL CITY, TX 78148
(210) 590-2544
(210) 590-2352 FAX
www.timbercon.net




FIRE EGRESS INFORMATION - FLOOR PLANS - ALTERNATE 1

 
SHEET NUMBER


F3.3


JULY 28, 2010

9/1/2010 1:21:12 PM, 1:1

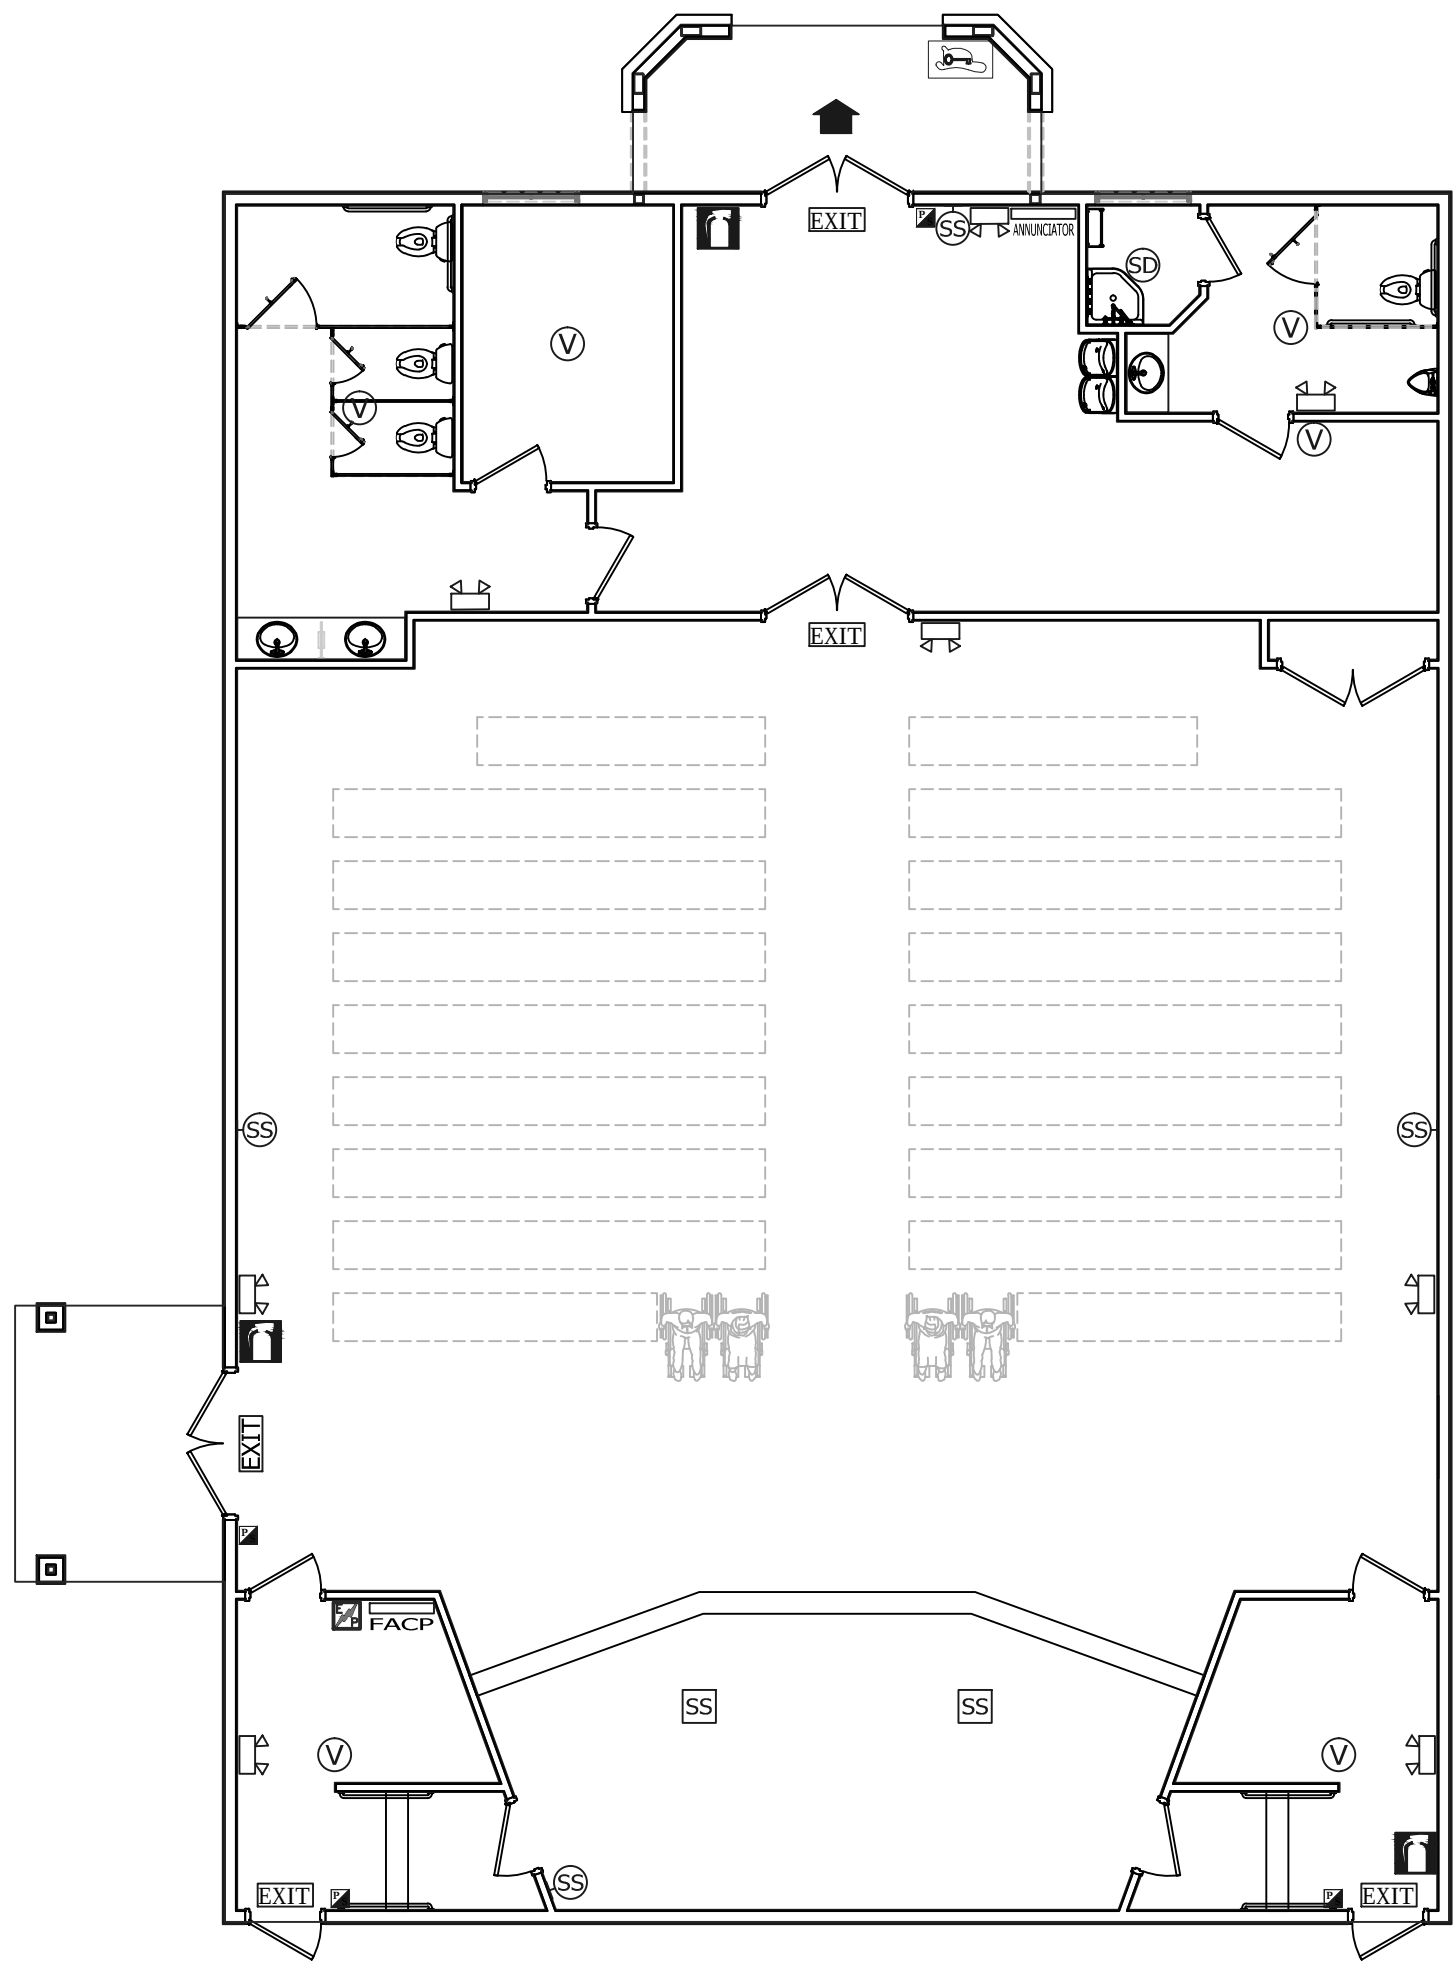


 
1 FIRE CONTROL SYSTEMS - CHAPEL
Scale: 1/8" = 1'  

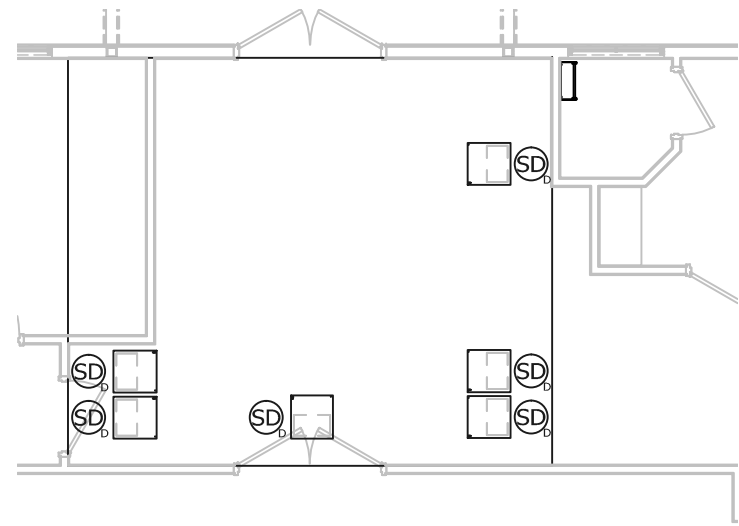



1A FIRE CONTROL SYSTEMS - CHAPEL MEZZ.
Scale: 1/8" = 1'  

LEGEND	
	FIRE ALARM CONTROL PANEL
	FIRE ALARM ANNUNCIATOR PANEL
	MAIN ELECTRICAL DISCONNECT
	DOMESTIC WATER SHUTOFF
	SPRINKLER SHUT OFF VALVE
	KITCHEN HOOD SUPPRESSION SYSTEM
	KITCHEN SYSTEM PULL STATION
	FIRE DEPARTMENT CONNECTION (F.D.C.)
	GAS SHUTOFF
	FIRE EXTINGUISHER
	MANUAL PULL STATION
	EXIT SIGN
	DIRECTION OF EGRESS
	SMOKE DETECTOR
	RETURN AIR DUCT SMOKE DETECTOR
	SPEAKER/STROBE
	SPEAKER/STROBE - FLOOR MOUNTED
	VISUAL STROBE
	BATTERY OPERATED EMERGENCY LIGHT
	MUNICIPAL FIRE HYDRANT
	PRIVATE FIRE HYDRANT
	KNOX BOX LOCATION
	MAIN ENTRANCE

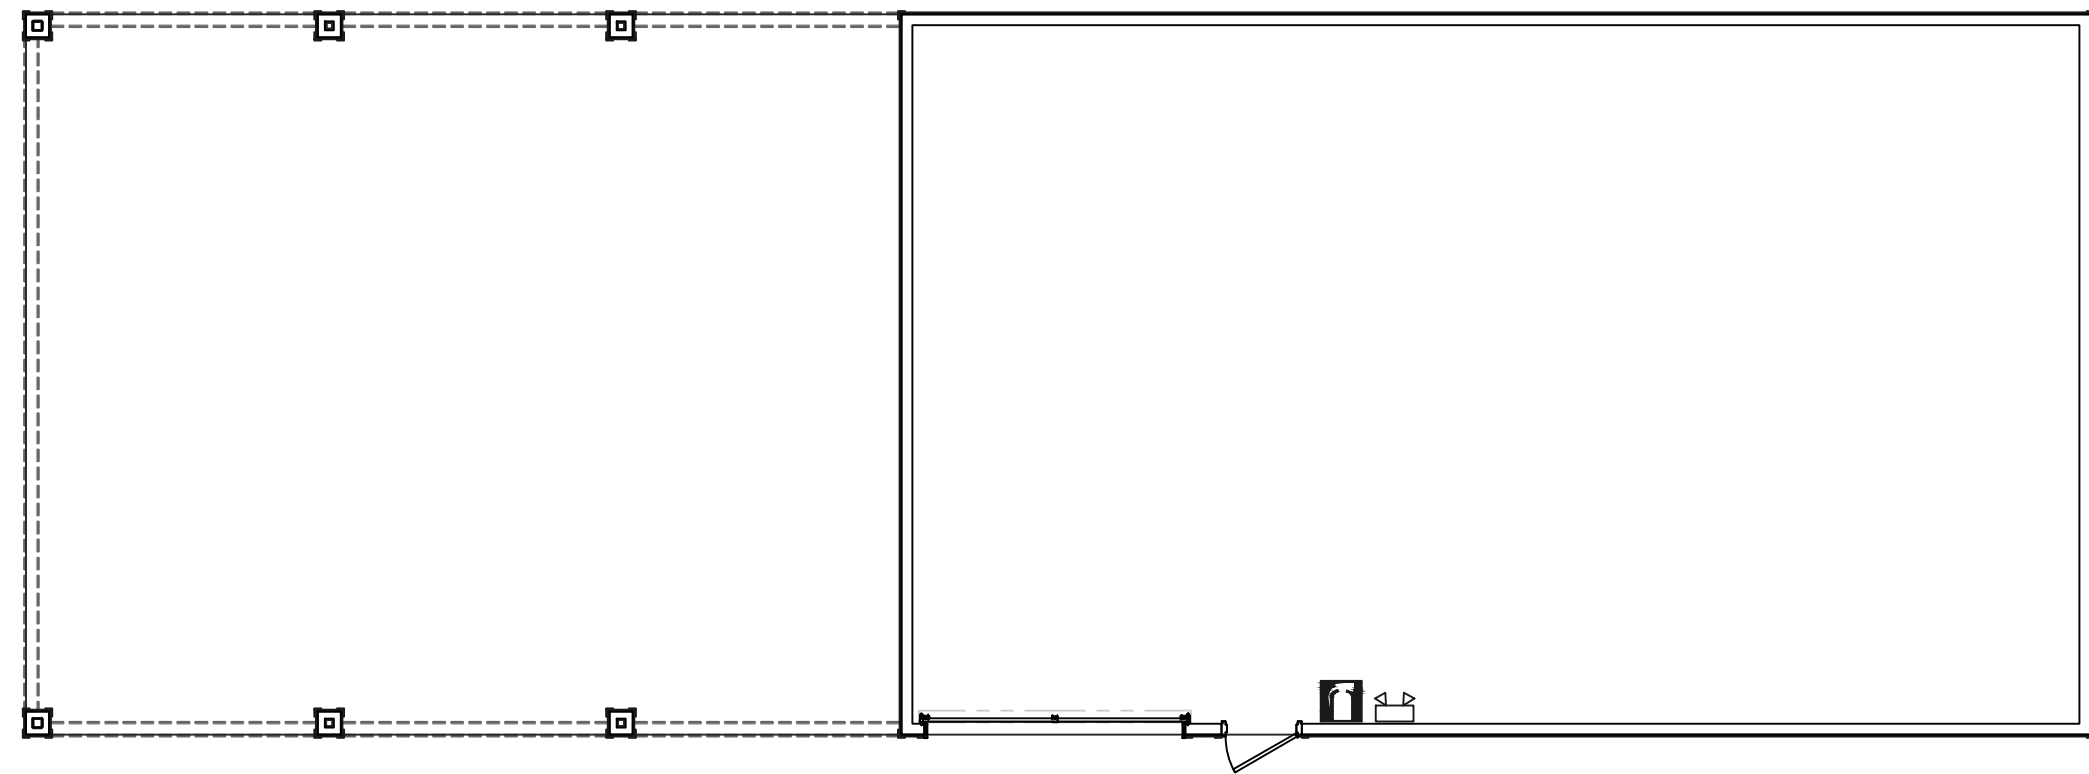

  
2 FIRE CONTROL SYSTEMS - GARAGE
Scale: 1/8" = 1'  

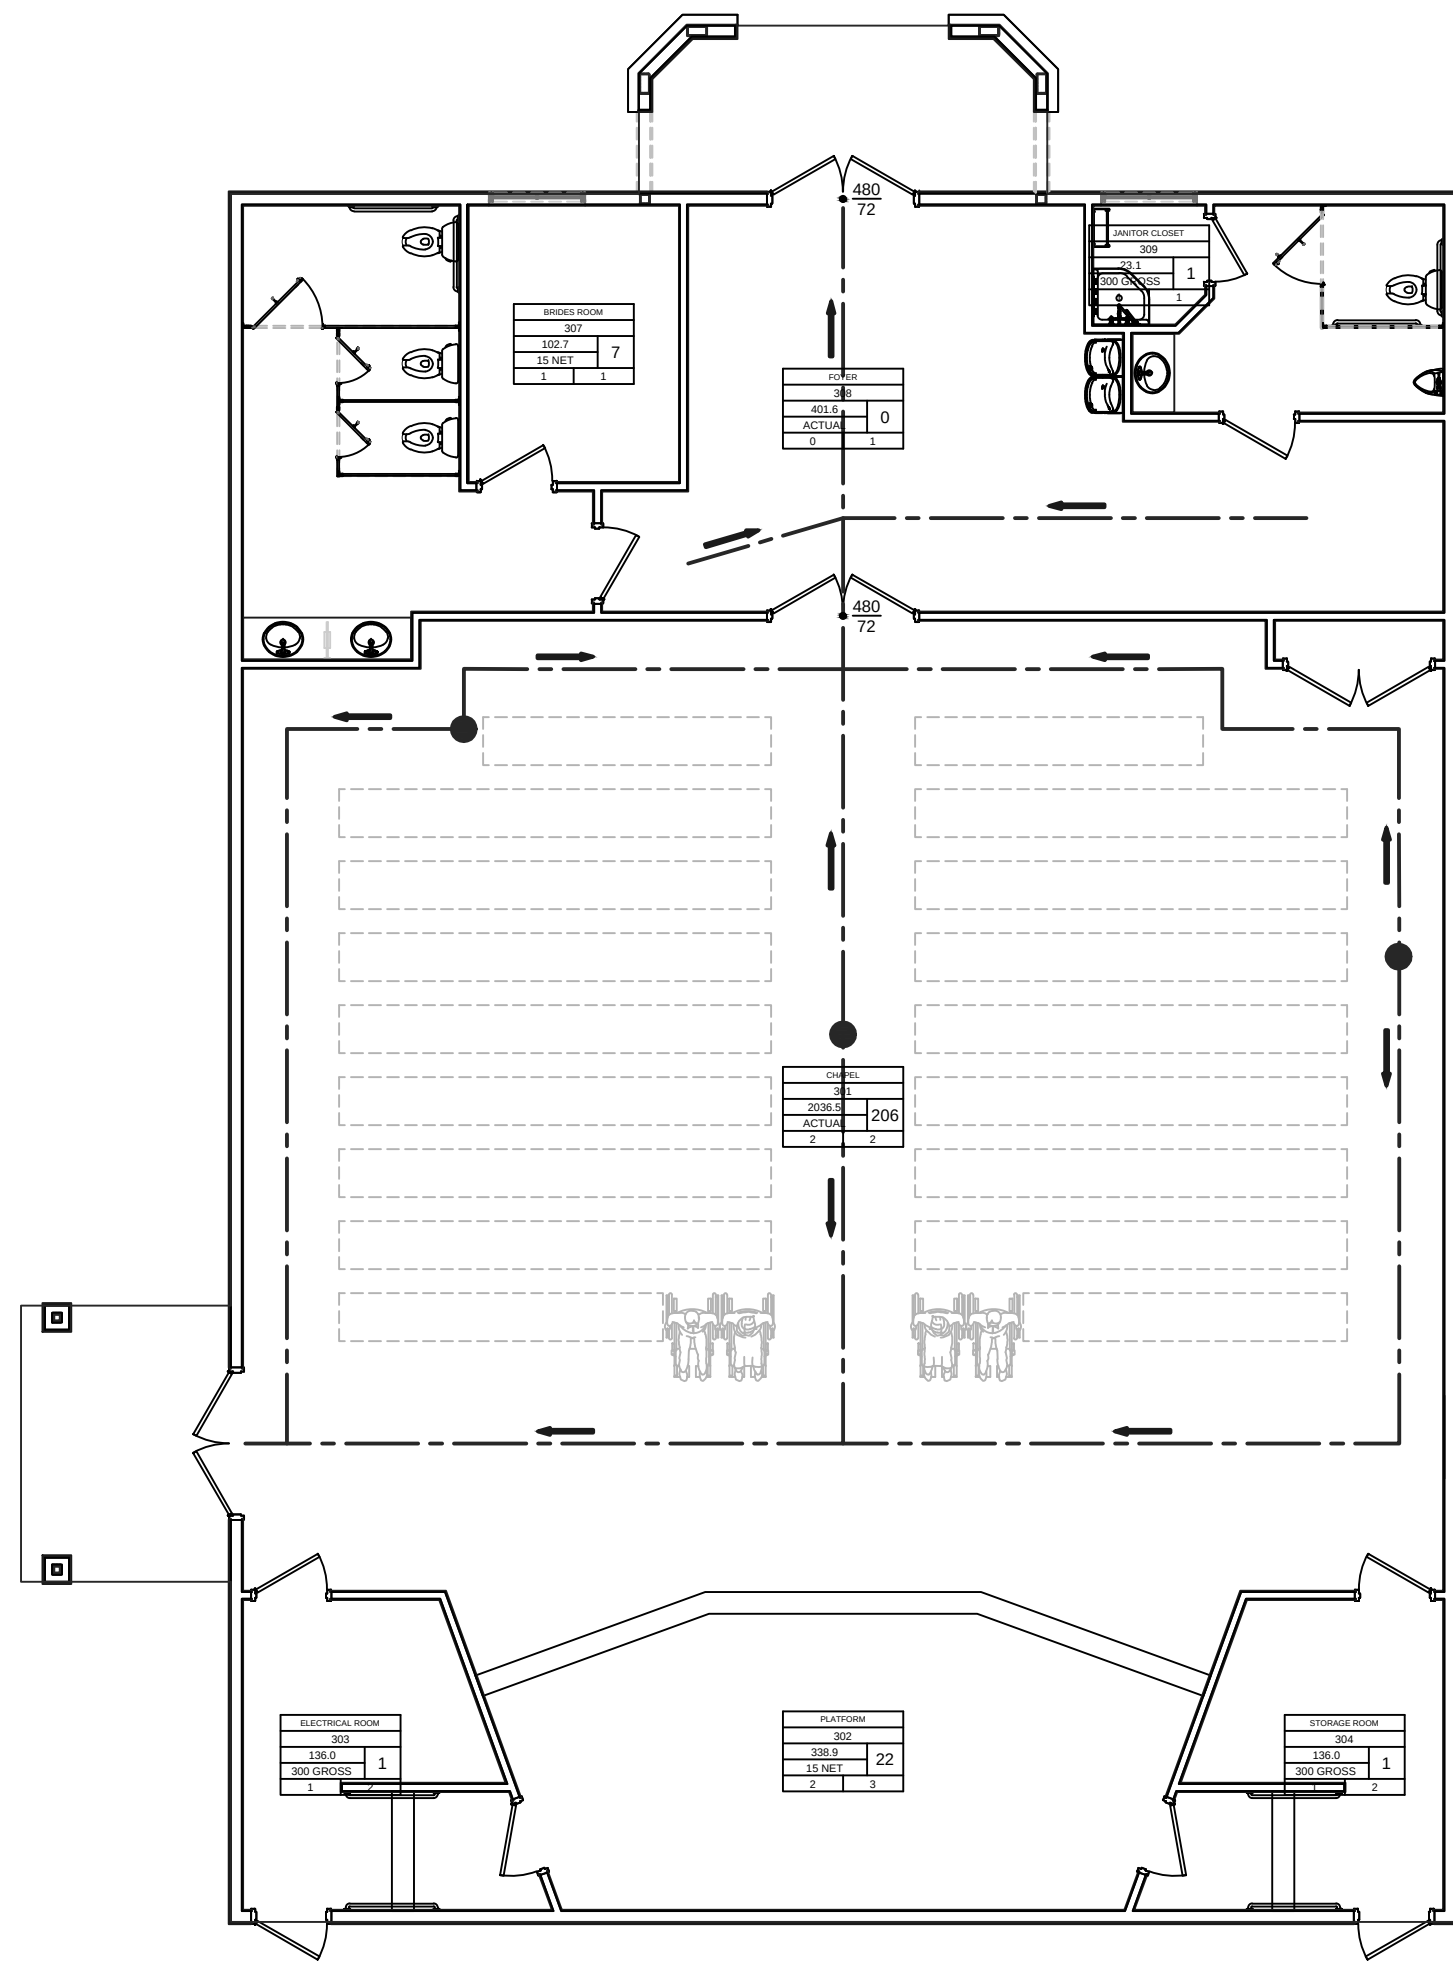


3 FIRE EGRESS INFORMATION - CHAPEL
Scale: 1/8" = 1'  

LEGEND	
ROOM DESCRIPTION/USE	
ROOM NUMBER	
SQUARE FOOTAGE	O.L.
O.L.F.	
EXITS REQ'D	EXITS PROVIDED

 O.L.F. OCCUPANCY LOAD FACTOR
O.L. OCCUPANCY LOAD
480/72 EGRESS CAPACITY
EGRESS WIDTH
FIRE EVACUATION ROUTE

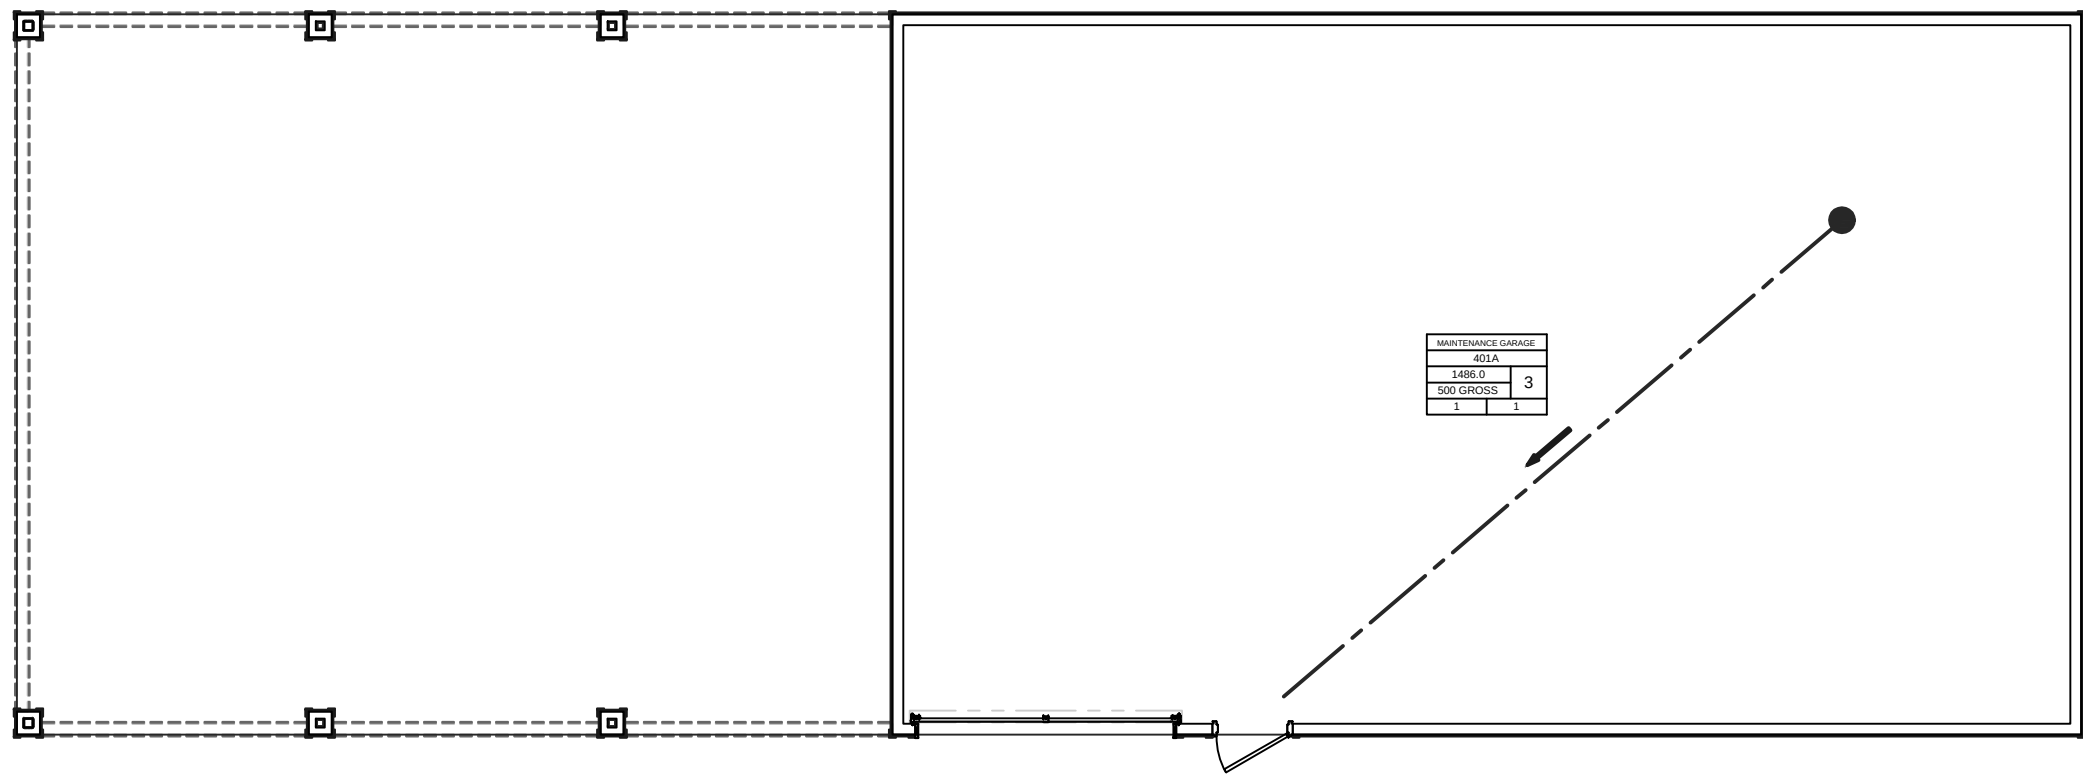

4 FIRE EGRESS INFORMATION - GARAGE
Scale: 1/8" = 1'  

REVISIONS:	
DATE	BY

These drawings and accompanying specifications are the sole property of Timbercon Construction, Inc. and may not be used for any other project or by any other person or general contractor without prior written permission from Timbercon Construction, Inc.

TRUE VISION CHURCH
2801 WILSON ROAD
KIRBY, TX 75753
(210) 590-4460
(210) 590-2540 FAX
www.truevisionchurch.org

TIMBERCON CONSTRUCTION, INC.
1241 UNIVERSAL CITY BLVD.
UNIVERSAL CITY, TX 78148
(210) 590-2544
(210) 590-2352 FAX
www.timbercon.net



FIRE CONTROL SYSTEMS & EGRESS INFO. - CHAPEL & GARAGE

SHEET NUMBER

F4.1

JULY 28, 2010